


**EQUIPMENT LIST**

DEVICE TYPE	UNITS	EQUIPMENT	MOUNTING	WATTAGE	DMX CHANNELS	FRAME SIZE	WEIGHT
Light	2	SELECON PL3		0	2		0
Light	2	PINSPOT		300	2		2
Light	3	HUNG BC GROUP		540	3		0
Light	4	PAR 64 MFL		1200	4		11.2
Light	7	MR 16 BIRDIE MFL		350	7		2.1
Light	12	ZOOM PROFILE 25-50 DEGREE		9600	12	190mm	92.4
Light	23	1.2K FRESNEL		14400	23	7 3/8"X7 3/8"	60
Light	23	ZOOM PROFILE 15-35 DEGREE		15475	23	190mm	177.1

**LEGEND**

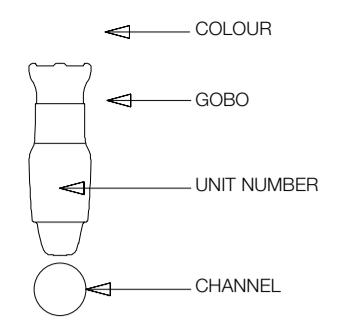

**FIXTURE TYPES**

**NOTES**

- FOR GENERAL NOTES REFER TO SHEET SL00-01
- DO NOT SCALE FROM THESE DRAWINGS
- ALL DIM TO BE TERMINATED
- R118 SHOULD BE PROVIDED FOR ALL PROFILES

**REVISIONS**

REV	DATE	BY	AMENDMENTS
B	8/10/12	DP	TOUR DRAFT - FOR PARTY APPROVAL
A	15/03/12	MP	INITIAL DRAFT

Preliminary

**BLUEBOTTLE 3 PTY LTD**  
 43 STAWELL STREET NORTH MELBOURNE  
 PHONE 61 3 9329 0709  
 FAX 61 3 9329 1780  
 EMAIL MAIL@BB3.NET.AU  
 PROFESSIONAL IN CONFIDENCE BLUEBOTTLE 3 PTY LTD

**ELECTRICAL DISCLAIMER**

ELECTRICAL CONTRACTOR TO ENSURE COMPLIANCE WITH ALL RELEVANT ELECTRICAL & BUILDING REGULATIONS.  
 BLUEBOTTLE 3 PTY LTD ACCEPTS NO RESPONSIBILITY FOR ENGINEERING, INSTALLATION OR COMPLIANCE OF ELECTRICAL WORKS.

**PROJECT**

NO. **J11234** NAME **JACK CHARLES VS THE CROWN - GENERIC TOUR**  
 CLIENT **ILBIJERRI THEATRE COMPANY**

**TITLE INFORMATION**

DESIGNER **DANNY PETTINGILL** VENUE **GENERIC**  
 DRAWN BY **BB** CHECKED BY **DP** SCALE **NTS** DATE **8/10/12**  
 DRAWING NUMBER - REVISION **SL00-00 B** ISSUE **TOUR DRAFT**


**DRAWING LIST**

DWG #	SHEET NAME	PLOT DATE	SHEET SCALE	DRAWN BY	CHECKED BY	ISSUE
SL00-00	INFORMATION	8/10/12	NTS	BB	DP	TOUR DRAFT
SL01-01	SET PLAN	8/10/12	1:50 @ A1	BB	FP	TOUR DRAFT
SL01-02	GENERAL SECTION	8/10/12	1:50 @ A1	BB	FP	TOUR DRAFT
SL02-01	LIGHTING PLAN	8/10/12	1:50 @ A1	BB	DP/FP	TOUR DRAFT
SL03-01	AV PLAN	8/10/12	1:50 @ A1	BB	FP	TOUR DRAFT
SL03-02	AV SCHEMATIC	8/10/12	NTS	BB	FP	TOUR DRAFT
SL04-01	BAND LAYOUT	8/10/12	NTS	BB	BH	TOUR DRAFT
SL05-01	INFORMATION - LANTERN SCHEDULE	8/10/12	NTS	BB	DP/FP	TOUR DRAFT
SL05-02	PATCH - CHANNEL SCHEDULE	8/10/12	NTS	BB	DP/FP	TOUR DRAFT

**LEGEND**

- ← COLOUR
- ← GOBO
- ← UNIT NUMBER
- ← CHANNEL

**FIXTURE TYPES**

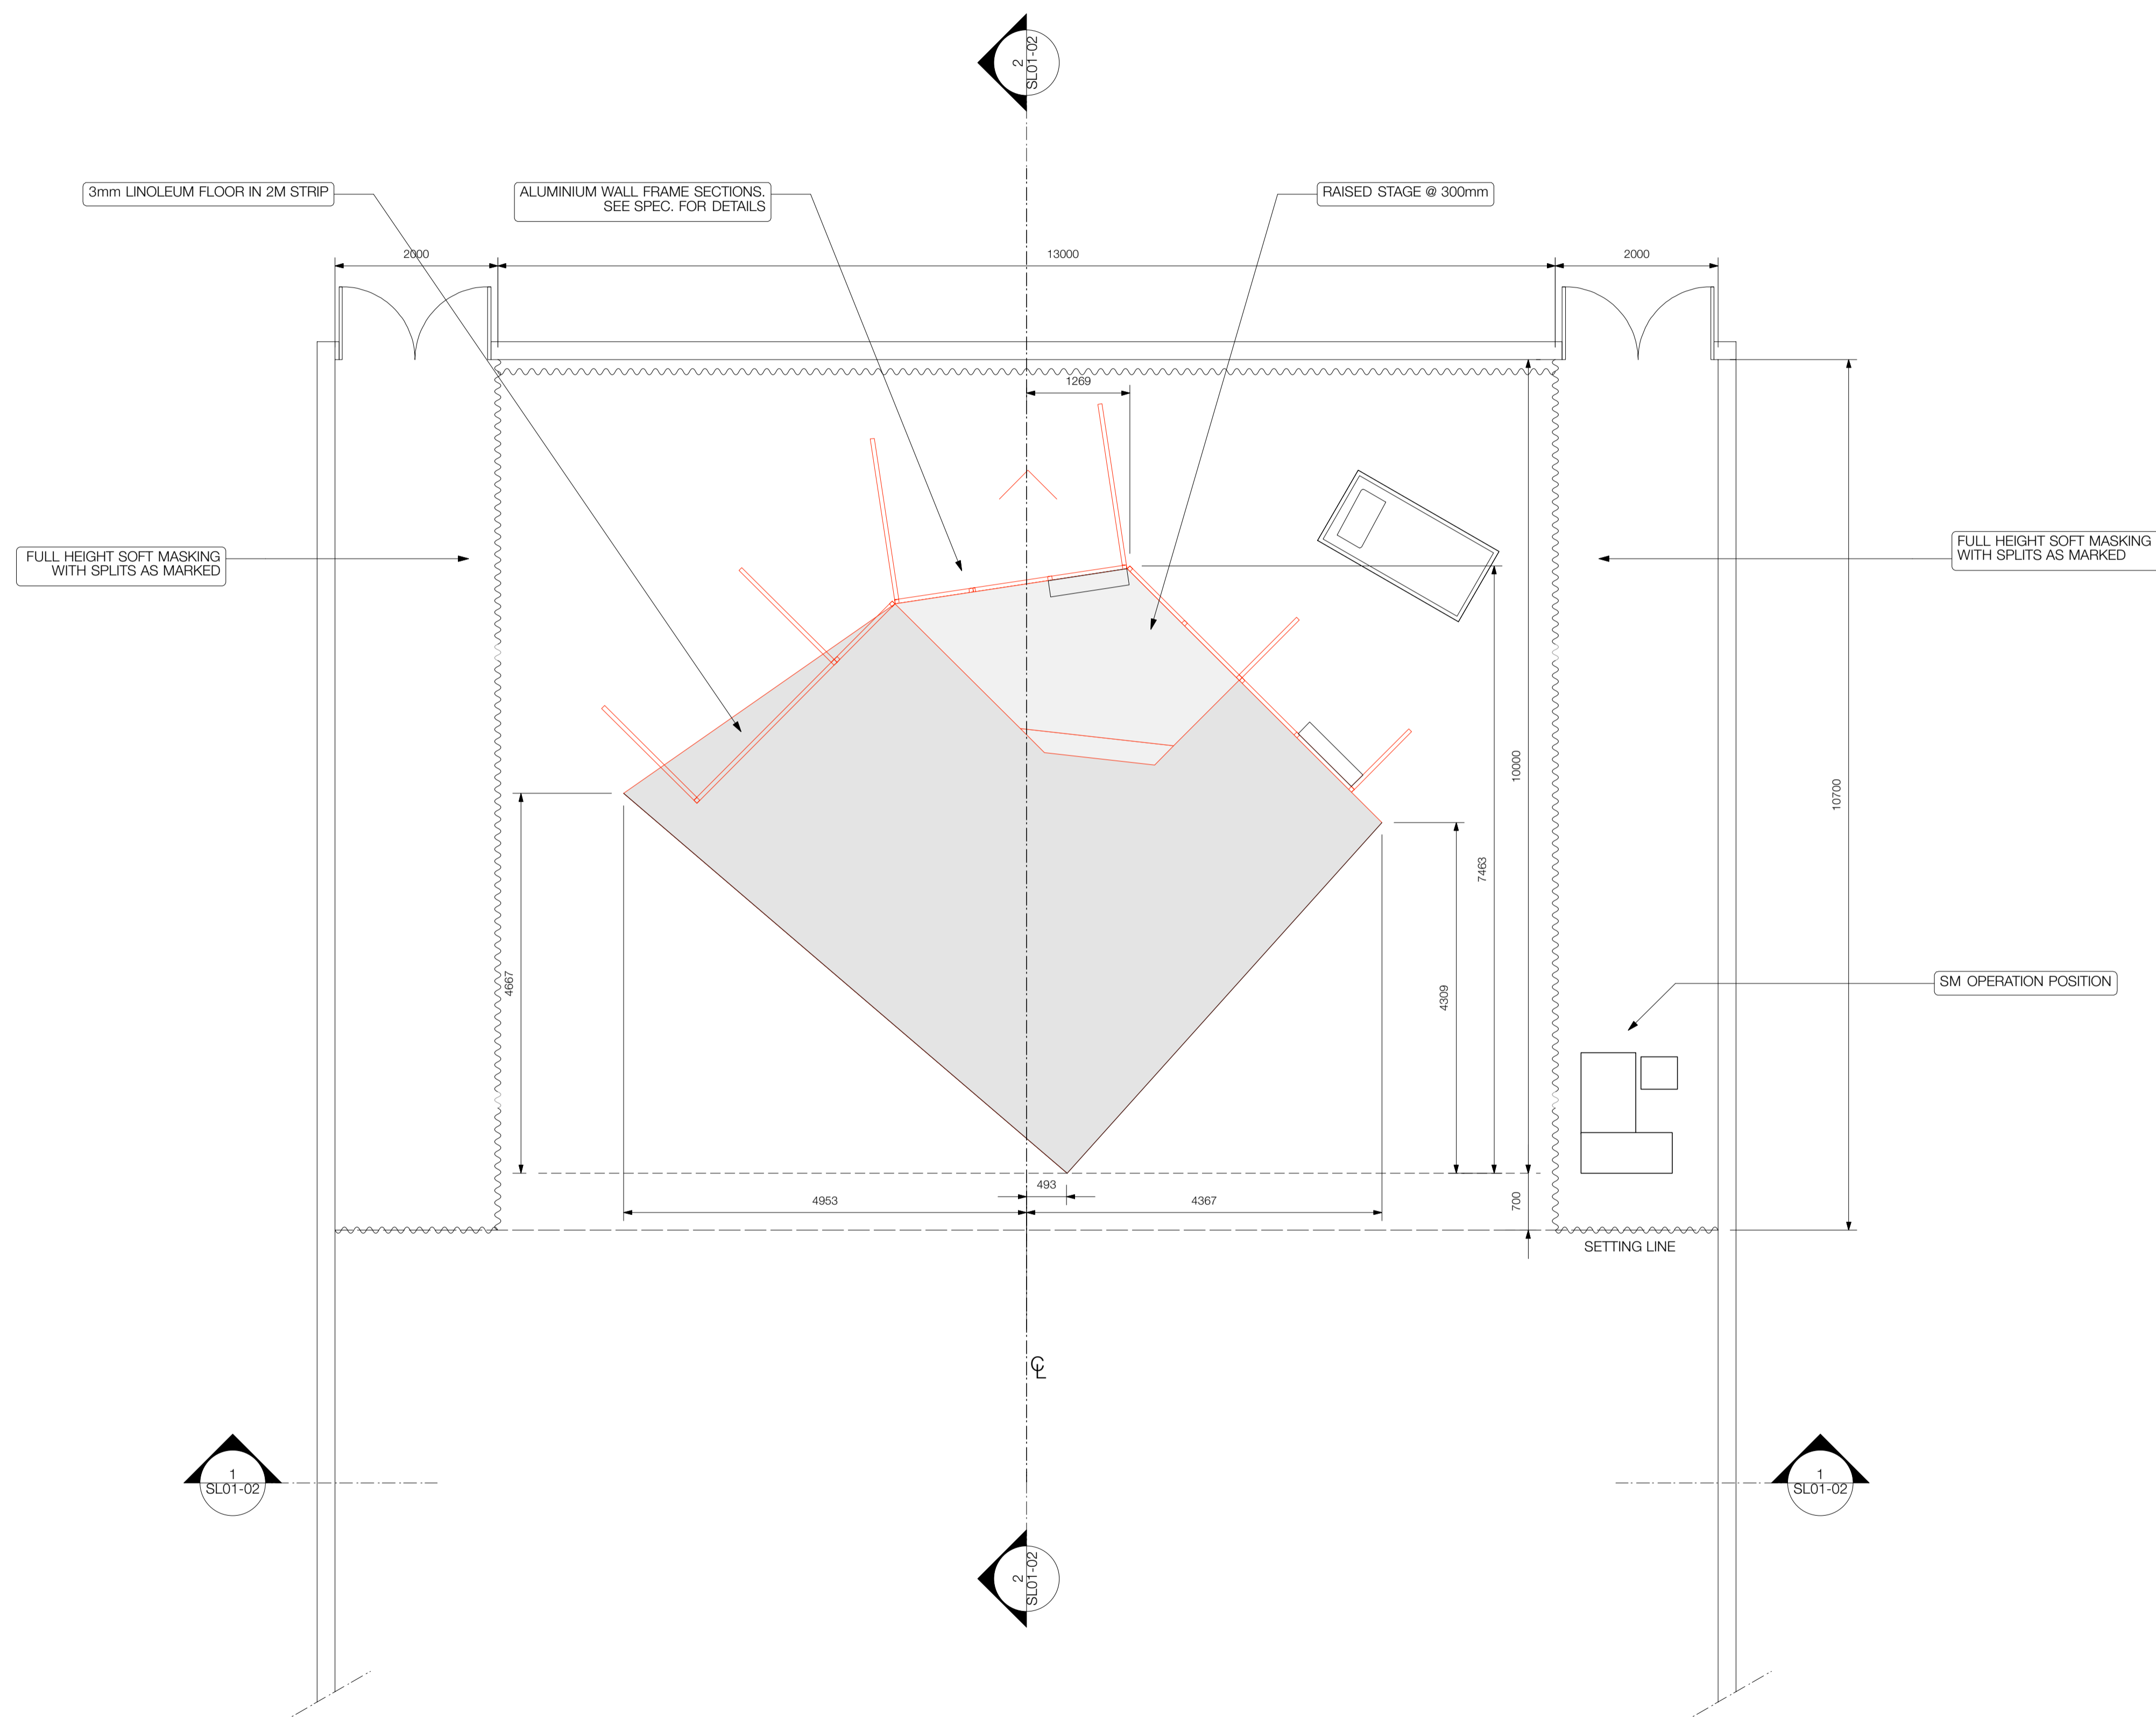

- NOTES**
1. FOR GENERAL NOTES REFER TO SHEET SLO0-01
  2. DO NOT SCALE FROM THESE DRAWINGS
  3. ALL DIM TO BE TERMINATED
  4. R118 SHOULD BE PROVIDED FOR ALL PROFILES

**REVISIONS**

<b>Preliminary</b>			
NO.	DATE	BY	AMENDMENTS
B	8/10/12	DP	TOUR DRAFT - FOR PARTY APPROVAL
A	15/03/12	MP	INITIAL DRAFT

**BLUEBOTTLE 3 PTY LTD**  
 43 STAWELL STREET NORTH MELBOURNE  
 PHONE 61 3 9329 0709  
 FAX 61 3 9329 1780  
 EMAIL MAIL@BB3.NET.AU  
 PROFESSIONAL IN CONFIDENCE BLUEBOTTLE 3 PTY LTD

**ELECTRICAL DISCLAIMER**  
 ELECTRICAL CONTRACTOR TO ENSURE COMPLIANCE WITH ALL RELEVANT ELECTRICAL & BUILDING REGULATIONS.  
 BLUEBOTTLE 3 PTY LTD ACCEPTS NO RESPONSIBILITY FOR ENGINEERING, INSTALLATION OR COMPLIANCE OF ELECTRICAL WORKS.

**PROJECT**

NO. **J11234** NAME **JACK CHARLES VS THE CROWN - GENERIC TOUR**

CLIENT **ILBIJERRI THEATRE COMPANY**


**TITLE**  
**SET PLAN**

DESIGNER **DANNY PETTINGILL** VENUE **GENERIC**

DRAWN BY **BB** CHECKED BY **FP** SCALE **1:50 @ A1** DATE **8/10/12**

DRAWING NUMBER - REVISION **SL01-01 B** ISSUE **TOUR DRAFT**


**1 PLAN**  
 SCALE 1/50 @ A1

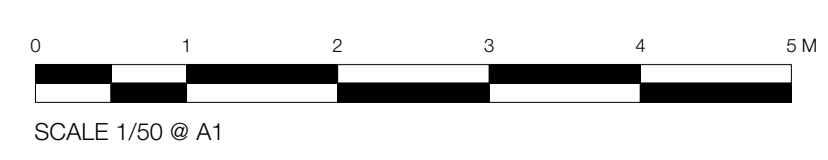


**LEGEND**

- ◀ COLOUR
- ◀ GOBO
- ◀ UNIT NUMBER
- ◀ CHANNEL

**FIXTURE TYPES**

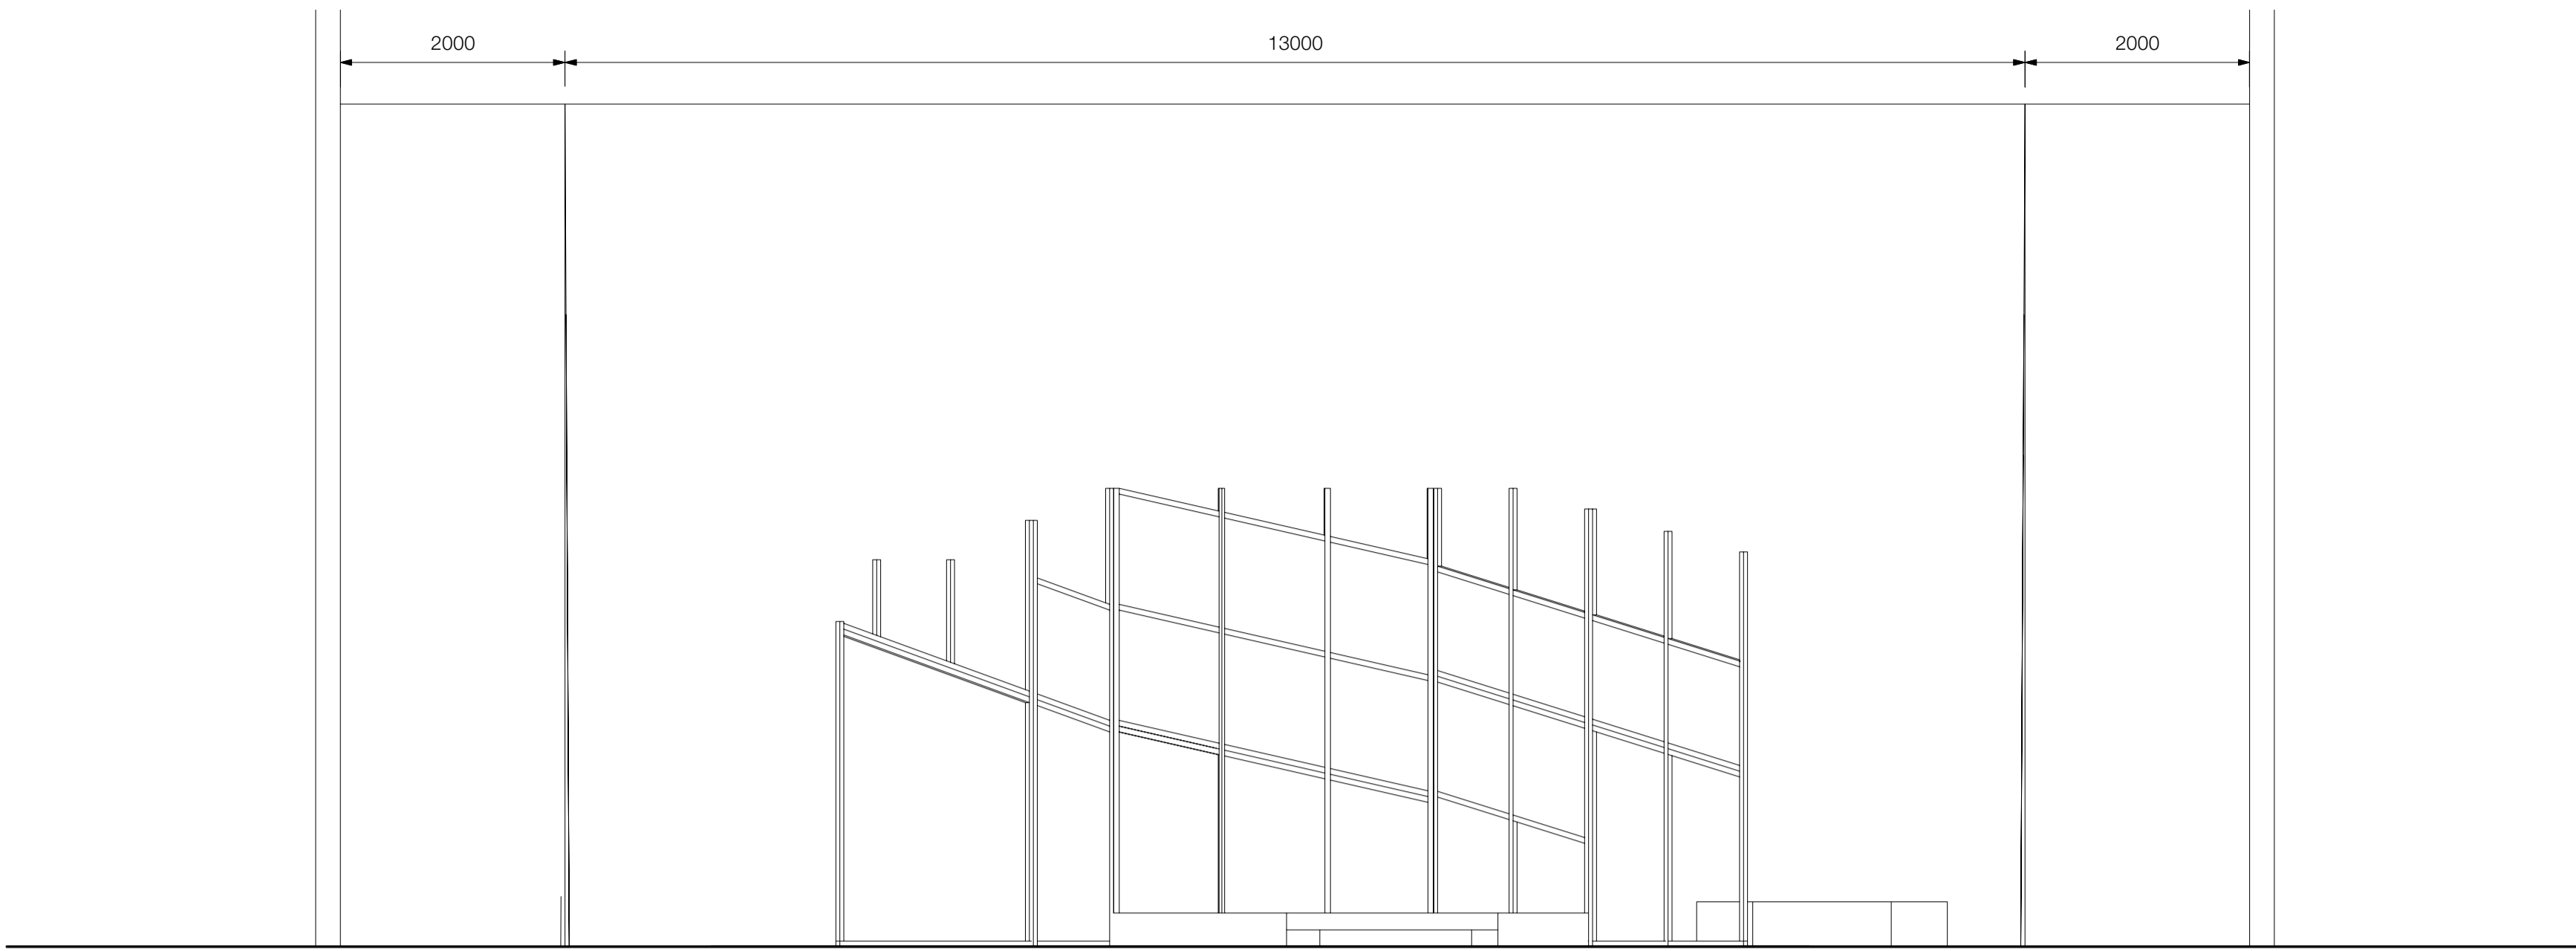

**1 FRONT ELEVATION**  
SL01-02 SCALE 1/50 @ A1

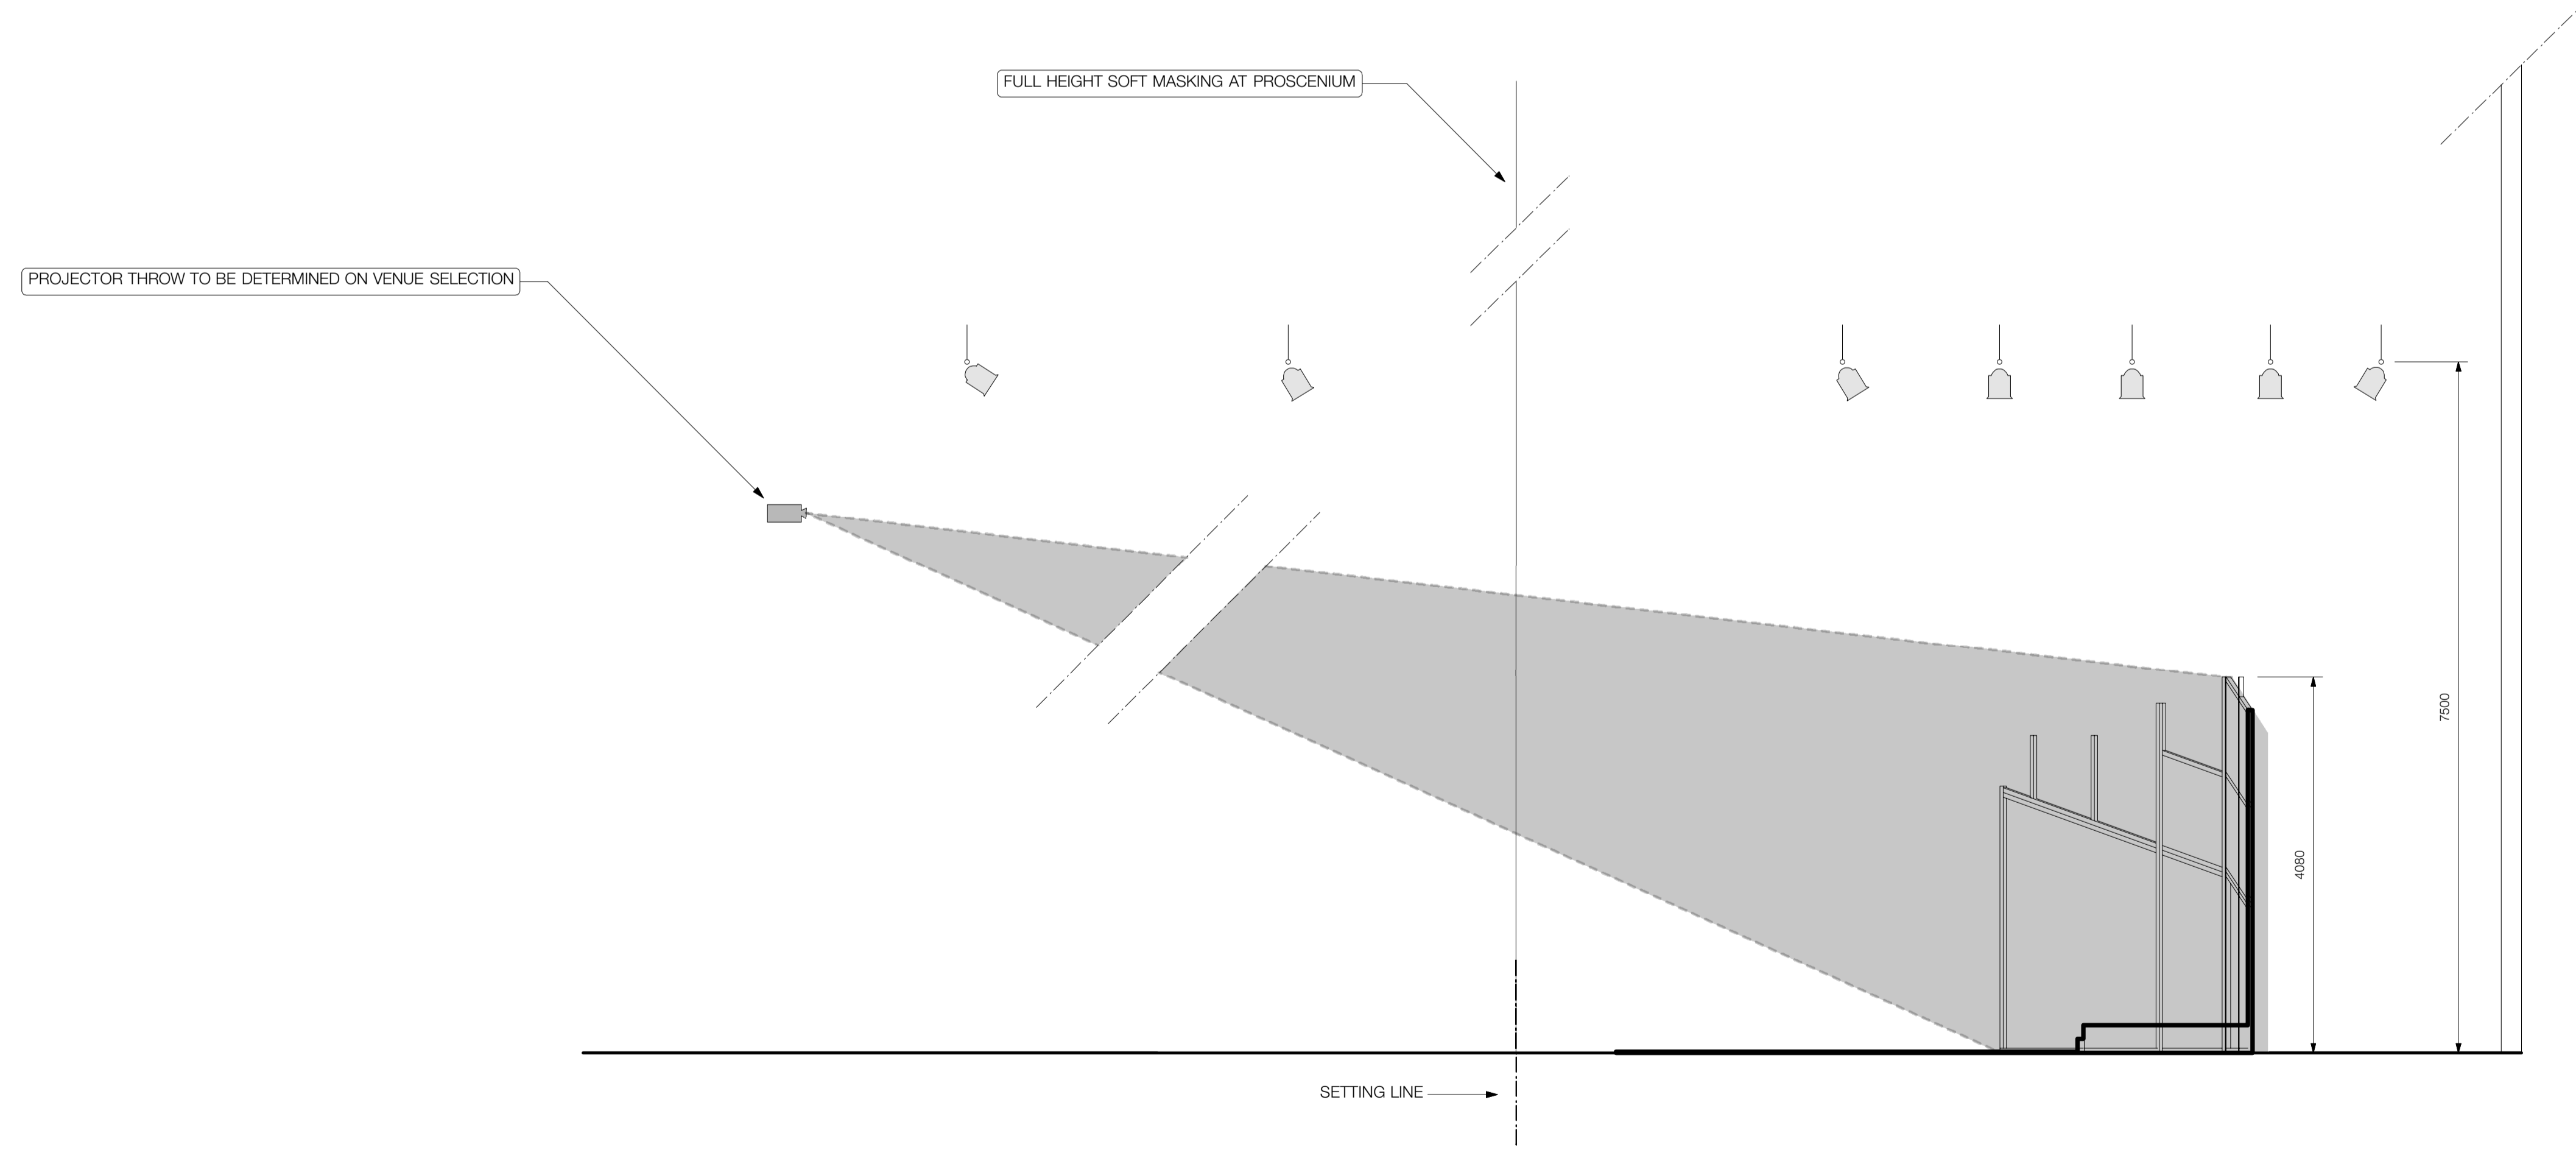

**2 SECTION**  
SL01-02 SCALE 1/50 @ A1

**NOTES**

1. FOR GENERAL NOTES REFER TO SHEET SL00-01
2. DO NOT SCALE FROM THESE DRAWINGS
3. ALL DIM TO BE TERMINATED
4. R118 SHOULD BE PROVIDED FOR ALL PROFILES

**REVISIONS**

REV	DATE	BY	AMENDMENTS
B	8/10/12	DP	TOUR DRAFT - FOR PARTY APPROVAL
A	15/03/12	MP	INITIAL DRAFT

**BLUEBOTTLE 3 PTY LTD**  
43 STAWELL STREET NORTH MELBOURNE  
PHONE 61 3 9329 0709  
FAX 61 3 9329 1780  
EMAIL MAIL@BB3.NET.AU  
PROFESSIONAL IN CONFIDENCE BLUEBOTTLE 3 PTY LTD

**ELECTRICAL DISCLAIMER**  
ELECTRICAL CONTRACTOR TO ENSURE COMPLIANCE WITH ALL RELEVANT ELECTRICAL & BUILDING REGULATIONS.  
BLUEBOTTLE 3 PTY LTD ACCEPTS NO RESPONSIBILITY FOR ENGINEERING, INSTALLATION OR COMPLIANCE OF ELECTRICAL WORKS.


**PROJECT**




NO. NAME  
J11234 JACK CHARLES VS THE CROWN - GENERIC TOUR

CLIENT  
ILBIJERRI THEATRE COMPANY

**TITLE**  
GENERAL SECTION

DESIGNER DANNY PETTINGILL	VENUE GENERIC
DRAWN BY BB	CHECKED BY FP
DRAWING NUMBER - REVISION SL01-02 B	SCALE DATE 1:50 @ A1 8/10/12
	ISSUE TOUR DRAFT

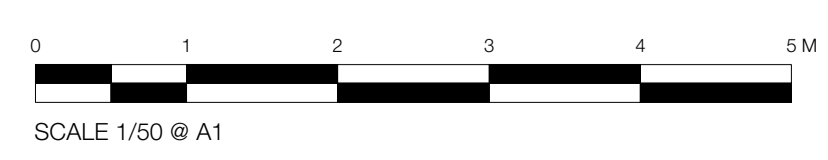

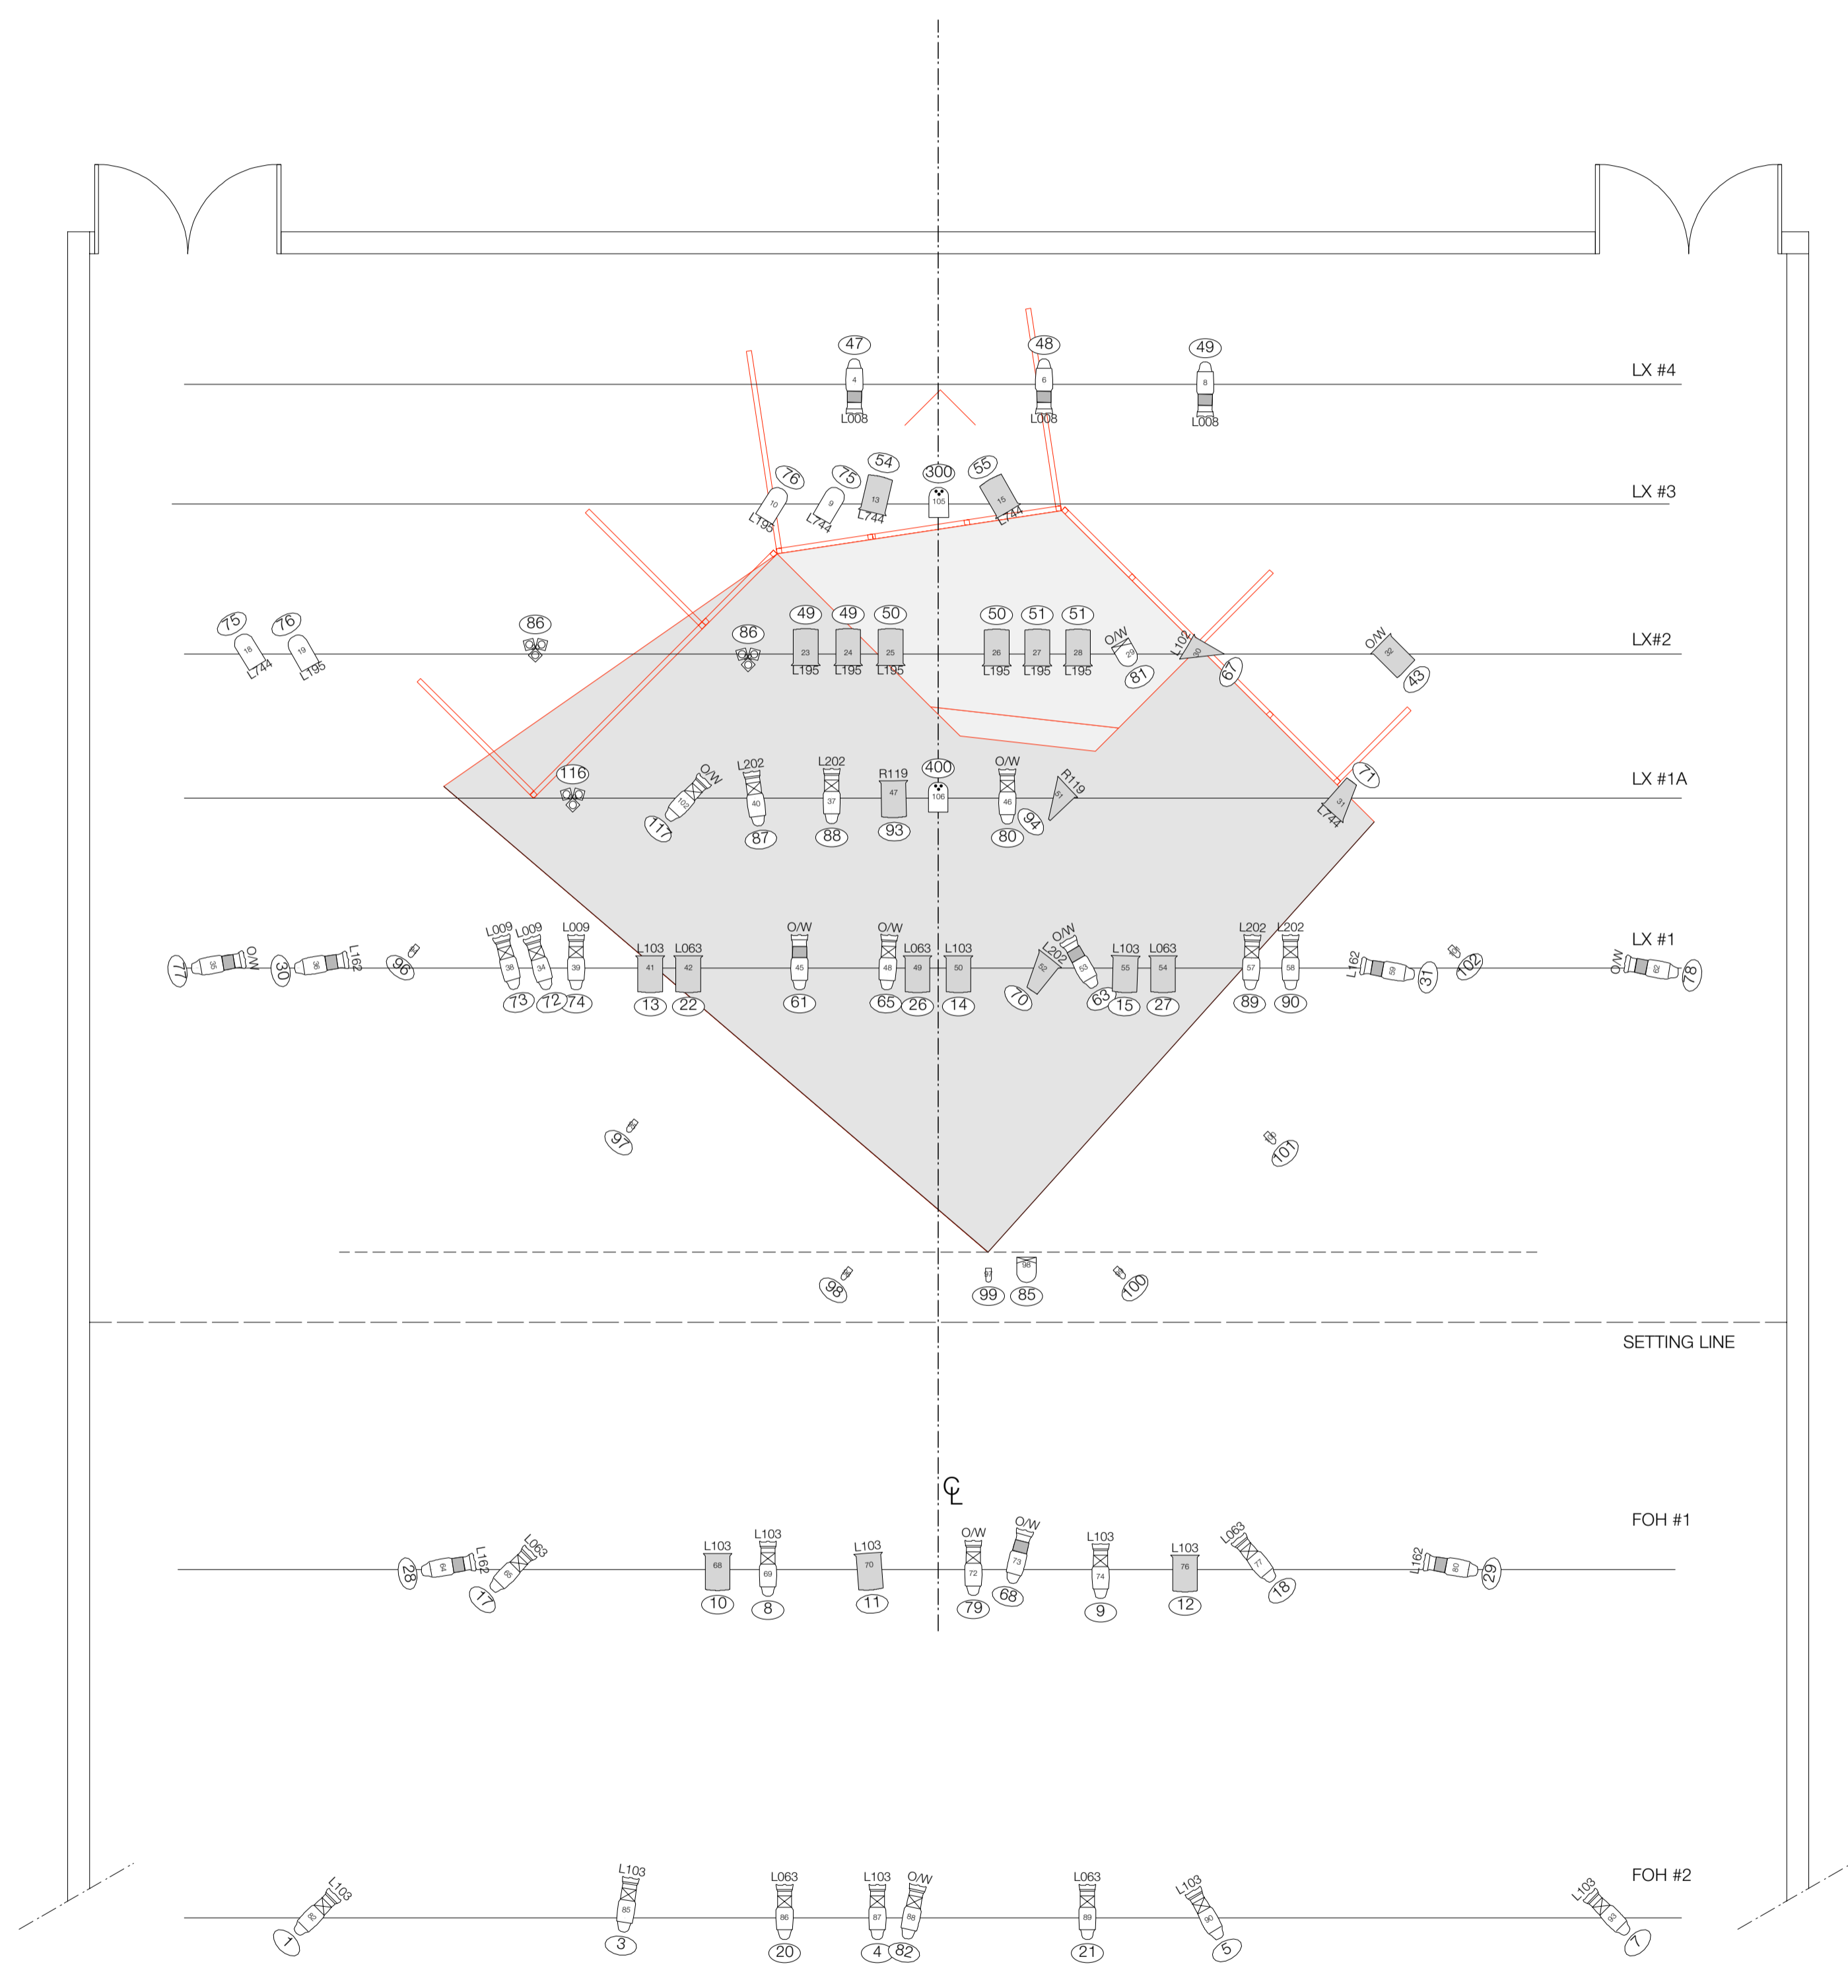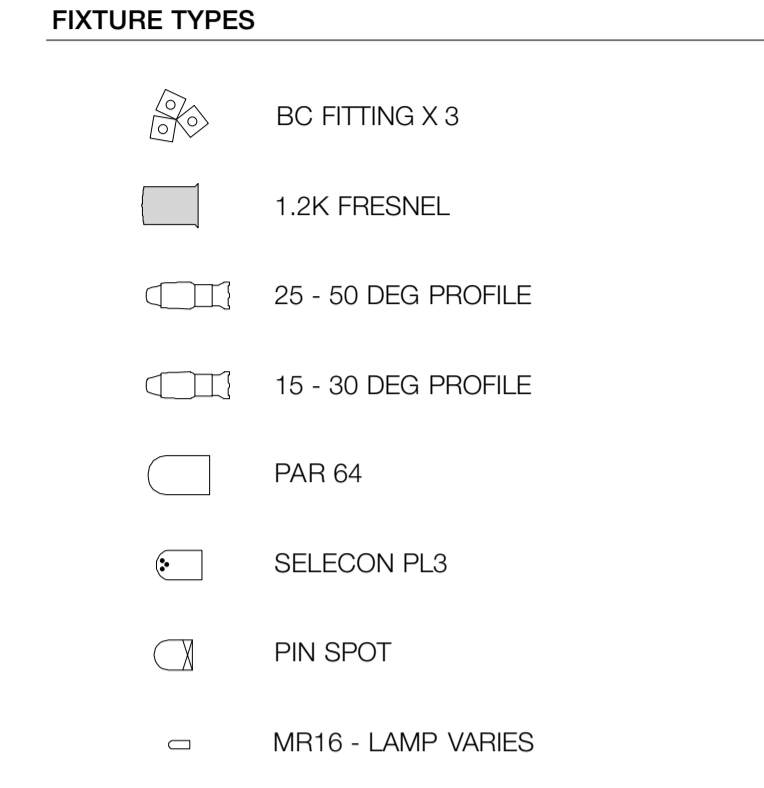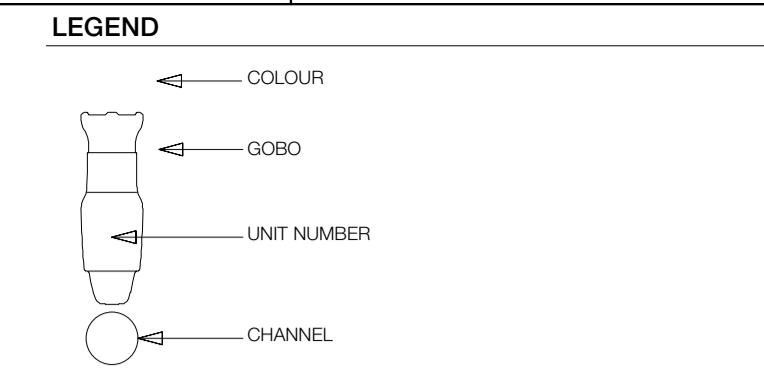

- NOTES**
- FOR GENERAL NOTES REFER TO SHEET SL00-01
  - DO NOT SCALE FROM THESE DRAWINGS
  - ALL DIM TO BE TERMINATED
  - R119 SHOULD BE PROVIDED FOR ALL PROFILES

**REVISIONS**

Preliminary			
REV	DATE	BY	AMENDMENTS
B	8/10/12	DP	TOUR DRAFT - FOR PARTY APPROVAL
A	15/03/12	MP	INITIAL DRAFT

**BLUEBOTTLE 3 PTY LTD**  
 43 STAWELL STREET NORTH MELBOURNE  
 PHONE 61 3 9329 0709  
 FAX 61 3 9329 1780  
 EMAIL MAIL@BB3.NET.AU  
 PROFESSIONAL IN CONFIDENCE BLUEBOTTLE 3 PTY LTD

**ELECTRICAL DISCLAIMER**  
 ELECTRICAL CONTRACTOR TO ENSURE COMPLIANCE WITH ALL RELEVANT ELECTRICAL & BUILDING REGULATIONS.  
 BLUEBOTTLE 3 PTY LTD ACCEPTS NO RESPONSIBILITY FOR ENGINEERING, INSTALLATION OR COMPLIANCE OF ELECTRICAL WORKS.

**PROJECT**


NO. J11234 NAME JACK CHARLES VS THE CROWN - GENERIC TOUR  
 CLIENT ILBIJERRI THEATRE COMPANY

**TITLE**  
 LIGHTING PLAN

DESIGNER DANNY PETTINGILL	CHECKED BY DP/PP	VENUE GENERIC	SCALE 1:50 @ A1	DATE 8/10/12
DRAWING NUMBER - REVISION SL02-01 B	ISSUE	TITLE TOUR DRAFT		

1 LIGHTING PLAN  
 SCALE 1/50 @ A1



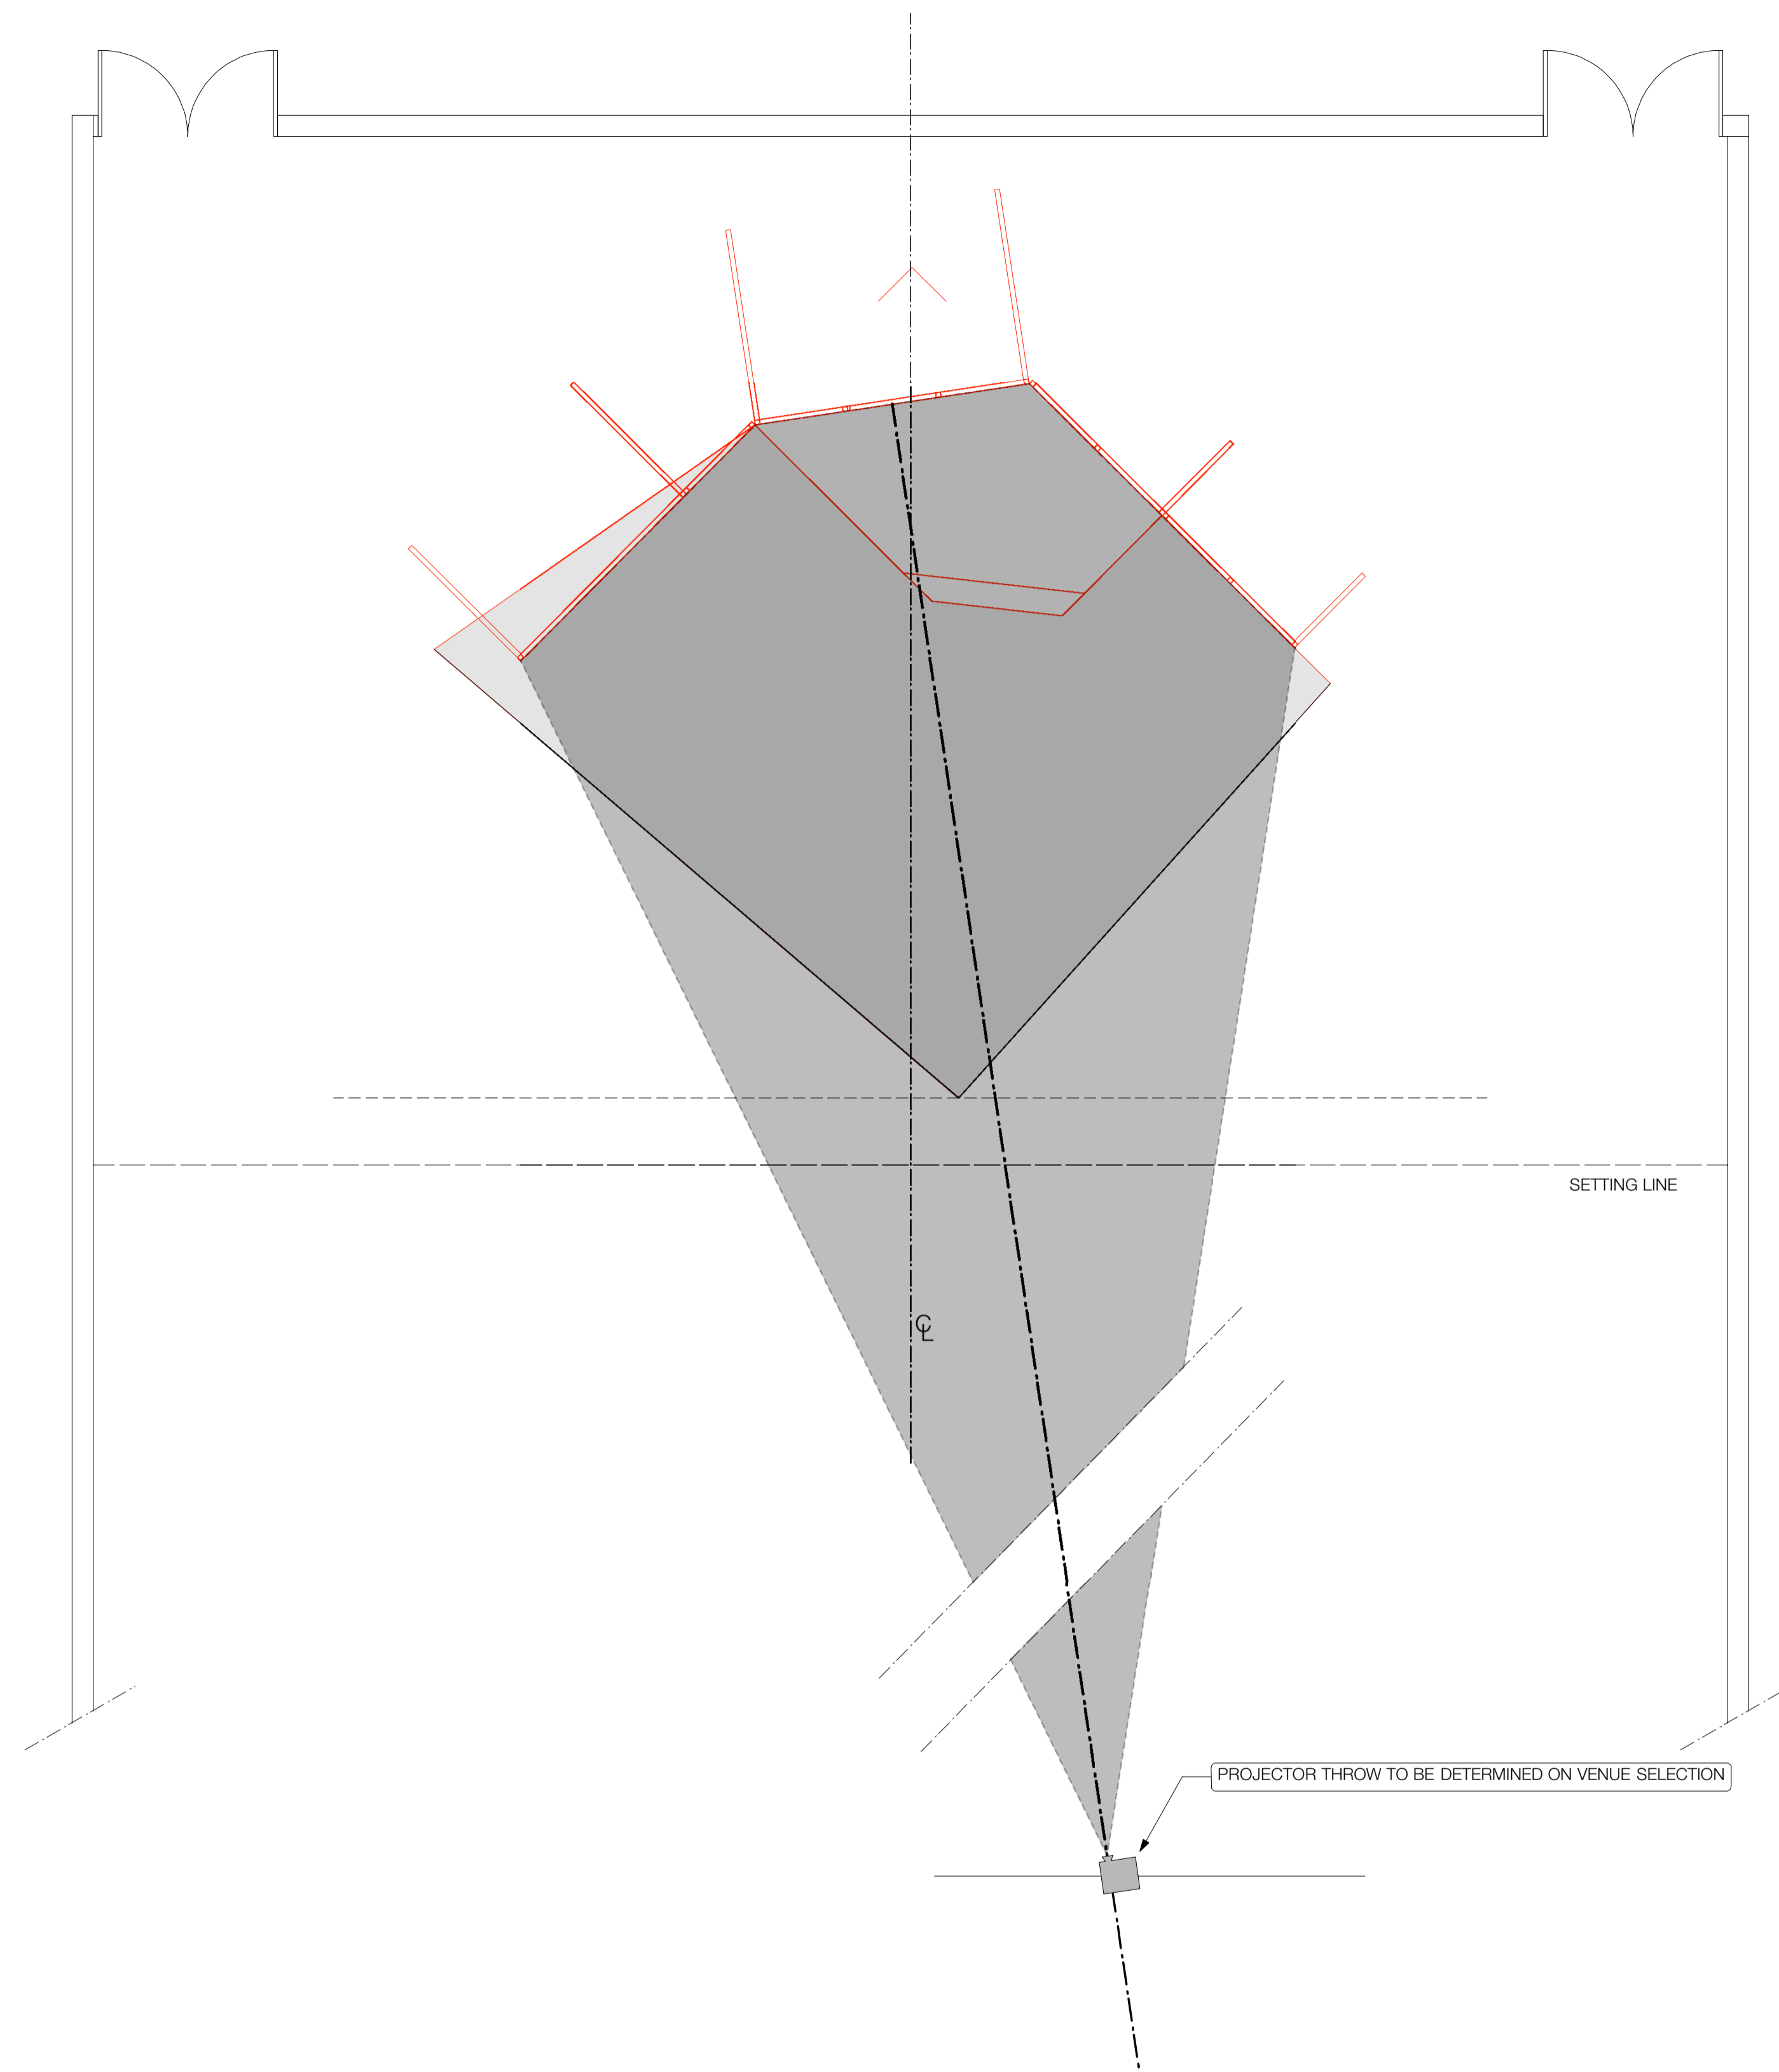

**LEGEND**

- ← COLOUR
- ← GOBO
- ← UNIT NUMBER
- ← CHANNEL

**FIXTURE TYPES**

- NOTES**
1. FOR GENERAL NOTES REFER TO SHEET SL00-01
  2. DO NOT SCALE FROM THESE DRAWINGS
  3. ALL DIM TO BE TERMINATED
  4. R118 SHOULD BE PROVIDED FOR ALL PROFILES

**REVISIONS**

REV	DATE	BY	AMENDMENTS
B	8/10/12	DP	TOUR DRAFT - FOR PARTY APPROVAL
A	15/03/12	MP	INITIAL DRAFT

**BLUEBOTTLE 3 PTY LTD**  
 43 STAWELL STREET NORTH MELBOURNE  
 PHONE 61 3 9329 0709  
 FAX 61 3 9329 1780  
 EMAIL MAIL@BB3.NET.AU

**ELECTRICAL DISCLAIMER**  
 ELECTRICAL CONTRACTOR TO ENSURE COMPLIANCE WITH ALL RELEVANT ELECTRICAL & BUILDING REGULATIONS.  
 BLUEBOTTLE 3 PTY LTD ACCEPTS NO RESPONSIBILITY FOR ENGINEERING, INSTALLATION OR COMPLIANCE OF ELECTRICAL WORKS.

 
**PROJECT**

NO.	NAME
J11234	JACK CHARLES VS THE CROWN - GENERIC TOUR
CLIENT	ILBIJERRI THEATRE COMPANY

**TITLE**  
**AV PLAN**

DESIGNER	DANNY PETTINGILL	VENUE	GENERIC
DRAWN BY	BB	CHECKED BY	PP
DRAWING NUMBER - REVISION	SL03-01 B	SCALE	1:50 @ A1
		DATE	8/10/12
		ISSUE	
		<b>ISSUE</b>	<b>TOUR DRAFT</b>


**1 PLAN**  
 SCALE 1/50 @ A1



**LEGEND**

- ◀ COLOUR
- ◀ GOBO
- ◀ UNIT NUMBER
- ◀ CHANNEL

**FIXTURE TYPES**

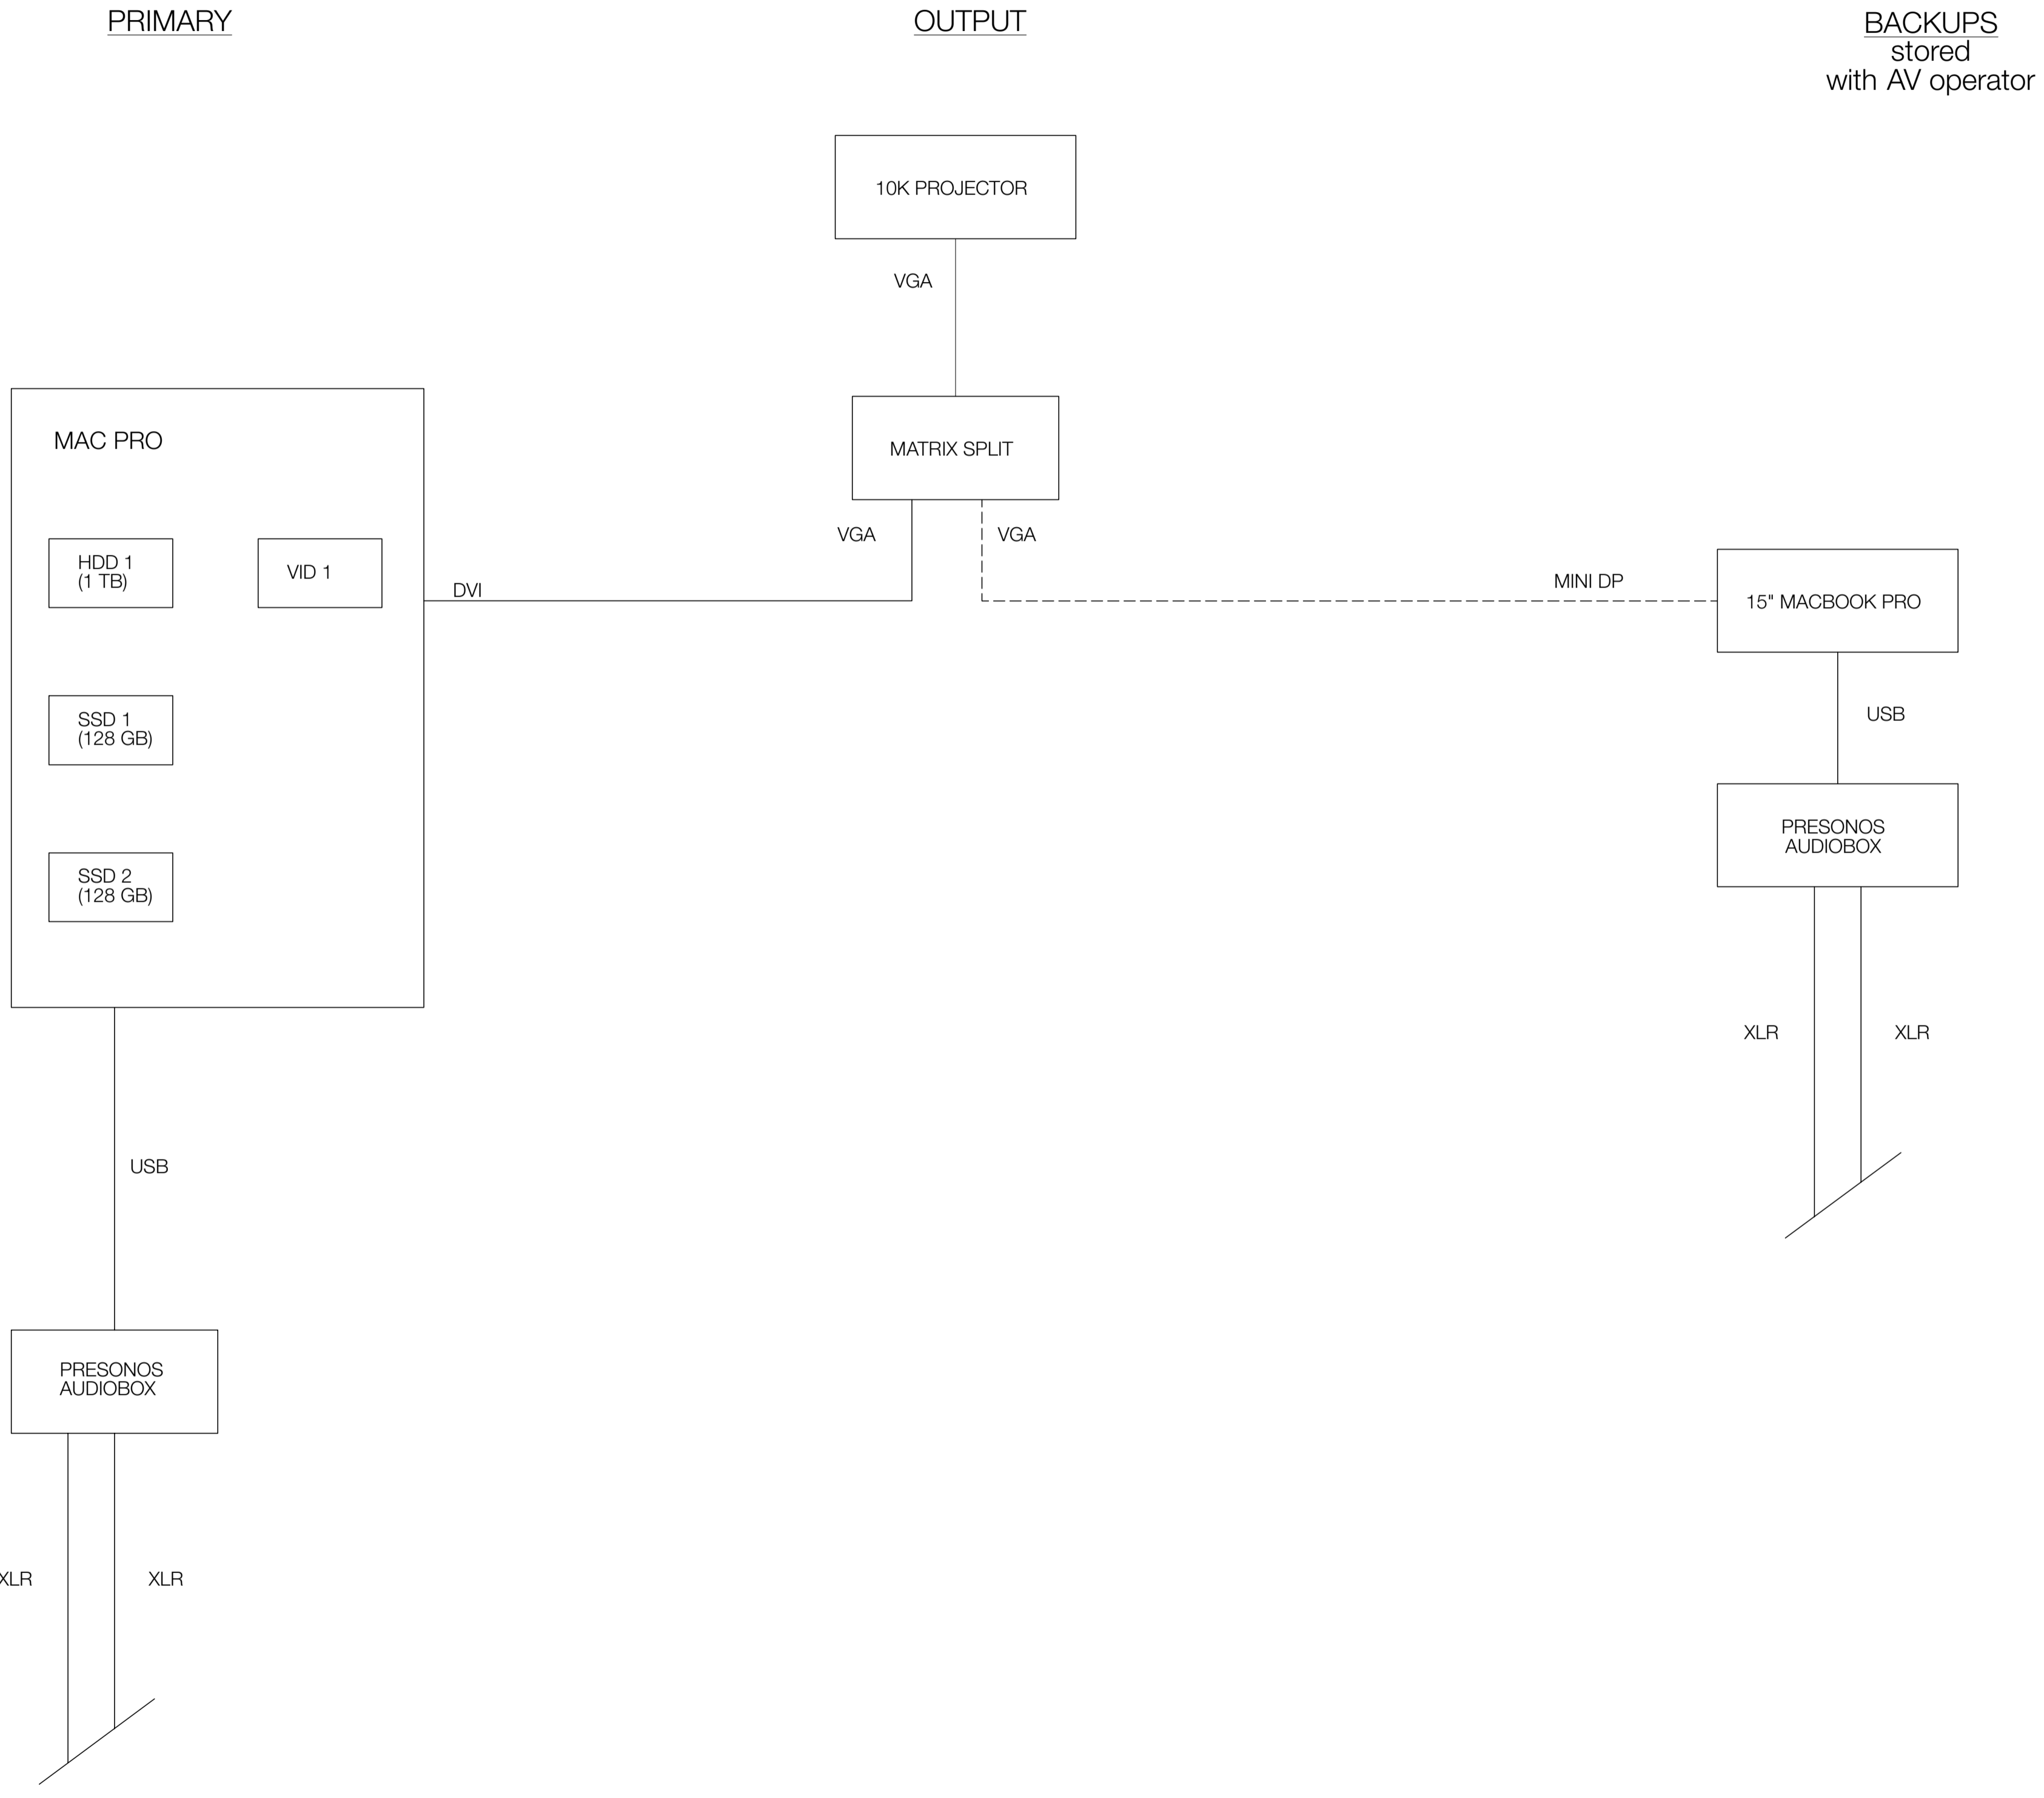

- NOTES**
1. FOR GENERAL NOTES REFER TO SHEET SL00-01
  2. DO NOT SCALE FROM THESE DRAWINGS
  3. ALL DIM TO BE TERMINATED
  4. R118 SHOULD BE PROVIDED FOR ALL PROFILES

**REVISIONS**

REV	DATE	BY	AMENDMENTS
B	8/10/12	DP	TOUR DRAFT - FOR PARTY APPROVAL
A	15/03/12	MP	INITIAL DRAFT

**BLUEBOTTLE 3 PTY LTD**  
 43 STAWELL STREET NORTH MELBOURNE  
 PHONE 61 3 9329 0709  
 FAX 61 3 9329 1780  
 EMAIL MAIL@BB3.NET.AU  
 PROFESSIONAL IN CONFIDENCE BLUEBOTTLE 3 PTY LTD

**ELECTRICAL DISCLAIMER**  
 ELECTRICAL CONTRACTOR TO ENSURE COMPLIANCE WITH ALL RELEVANT ELECTRICAL & BUILDING REGULATIONS.  
 BLUEBOTTLE 3 PTY LTD ACCEPTS NO RESPONSIBILITY FOR ENGINEERING, INSTALLATION OR COMPLIANCE OF ELECTRICAL WORKS.

**PROJECT**

NO. J11234 NAME JACK CHARLES VS THE CROWN - GENERIC TOUR  
 CLIENT ILBIJERRI THEATRE COMPANY

**TITLE**  
**AV SCHEMATIC**

DESIGNER DANNY PETTINGILL	CHECKED BY NTS	VENUE GENERIC	DATE 8/10/12
DRAWN BY BB	SCALE 1:1	ISSUE SL03-02 B	DATE 8/10/12

**1 AV SCHEMATIC**  
 SL03-02 NOT TO SCALE

**LEGEND**

← COLOUR  
 ← GOBO  
 ← UNIT NUMBER  
 ○ CHANNEL


**FIXTURE TYPES**

DRUMS/PERCUSSION -  
 2 X OVERHEAD MICS (W/ TALL BOOM STANDS & SHOT BAGS)  
 1 X VOX MIC (W/ STANDARD BOOM STAND)  
 1 X SNARE MIC (W/ STAND)  
 1 X KICK MIC (W/ STAND)  
 1 X SEMI-OPEN HEADPHONES  
 1 X FOLDBACK WEDGE

BASS GUITAR -  
 1 X VOX MIC (W/ STANDARD BOOM STAND)  
 1 X DI CHANNEL (BASS GUITAR)  
 1 X GUITAR STAND  
 1 X FOLDBACK WEDGE

VOX/GUITAR -  
 1 X VOX MIC (W/ STANDARD BOOM STAND)  
 1 X GUITAR STAND  
 1 X INSTRUMENT MIC (W/ SHORT BOOM STAND)  
 1 X FOLDBACK WEDGE

MUSICAL DIRECTOR -  
 1 X VOX MIC (W/ STANDARD BOOM STAND)  
 2 X STEREO DI'S (4 CHANNELS - COMPUTER INTERFACE OUTPUTS)  
 1 X DI CHANNEL (ELECTRIC VIOLIN)  
 1 X DI CHANNEL (GUITAR)  
 1 X MIC LINE (ACOUSTIC VIOLIN)  
 1 X KEYBOARD STAND  
 1 X GUITAR STAND  
 1 X VIOLIN STAND  
 1 X FOLDBACK WEDGE

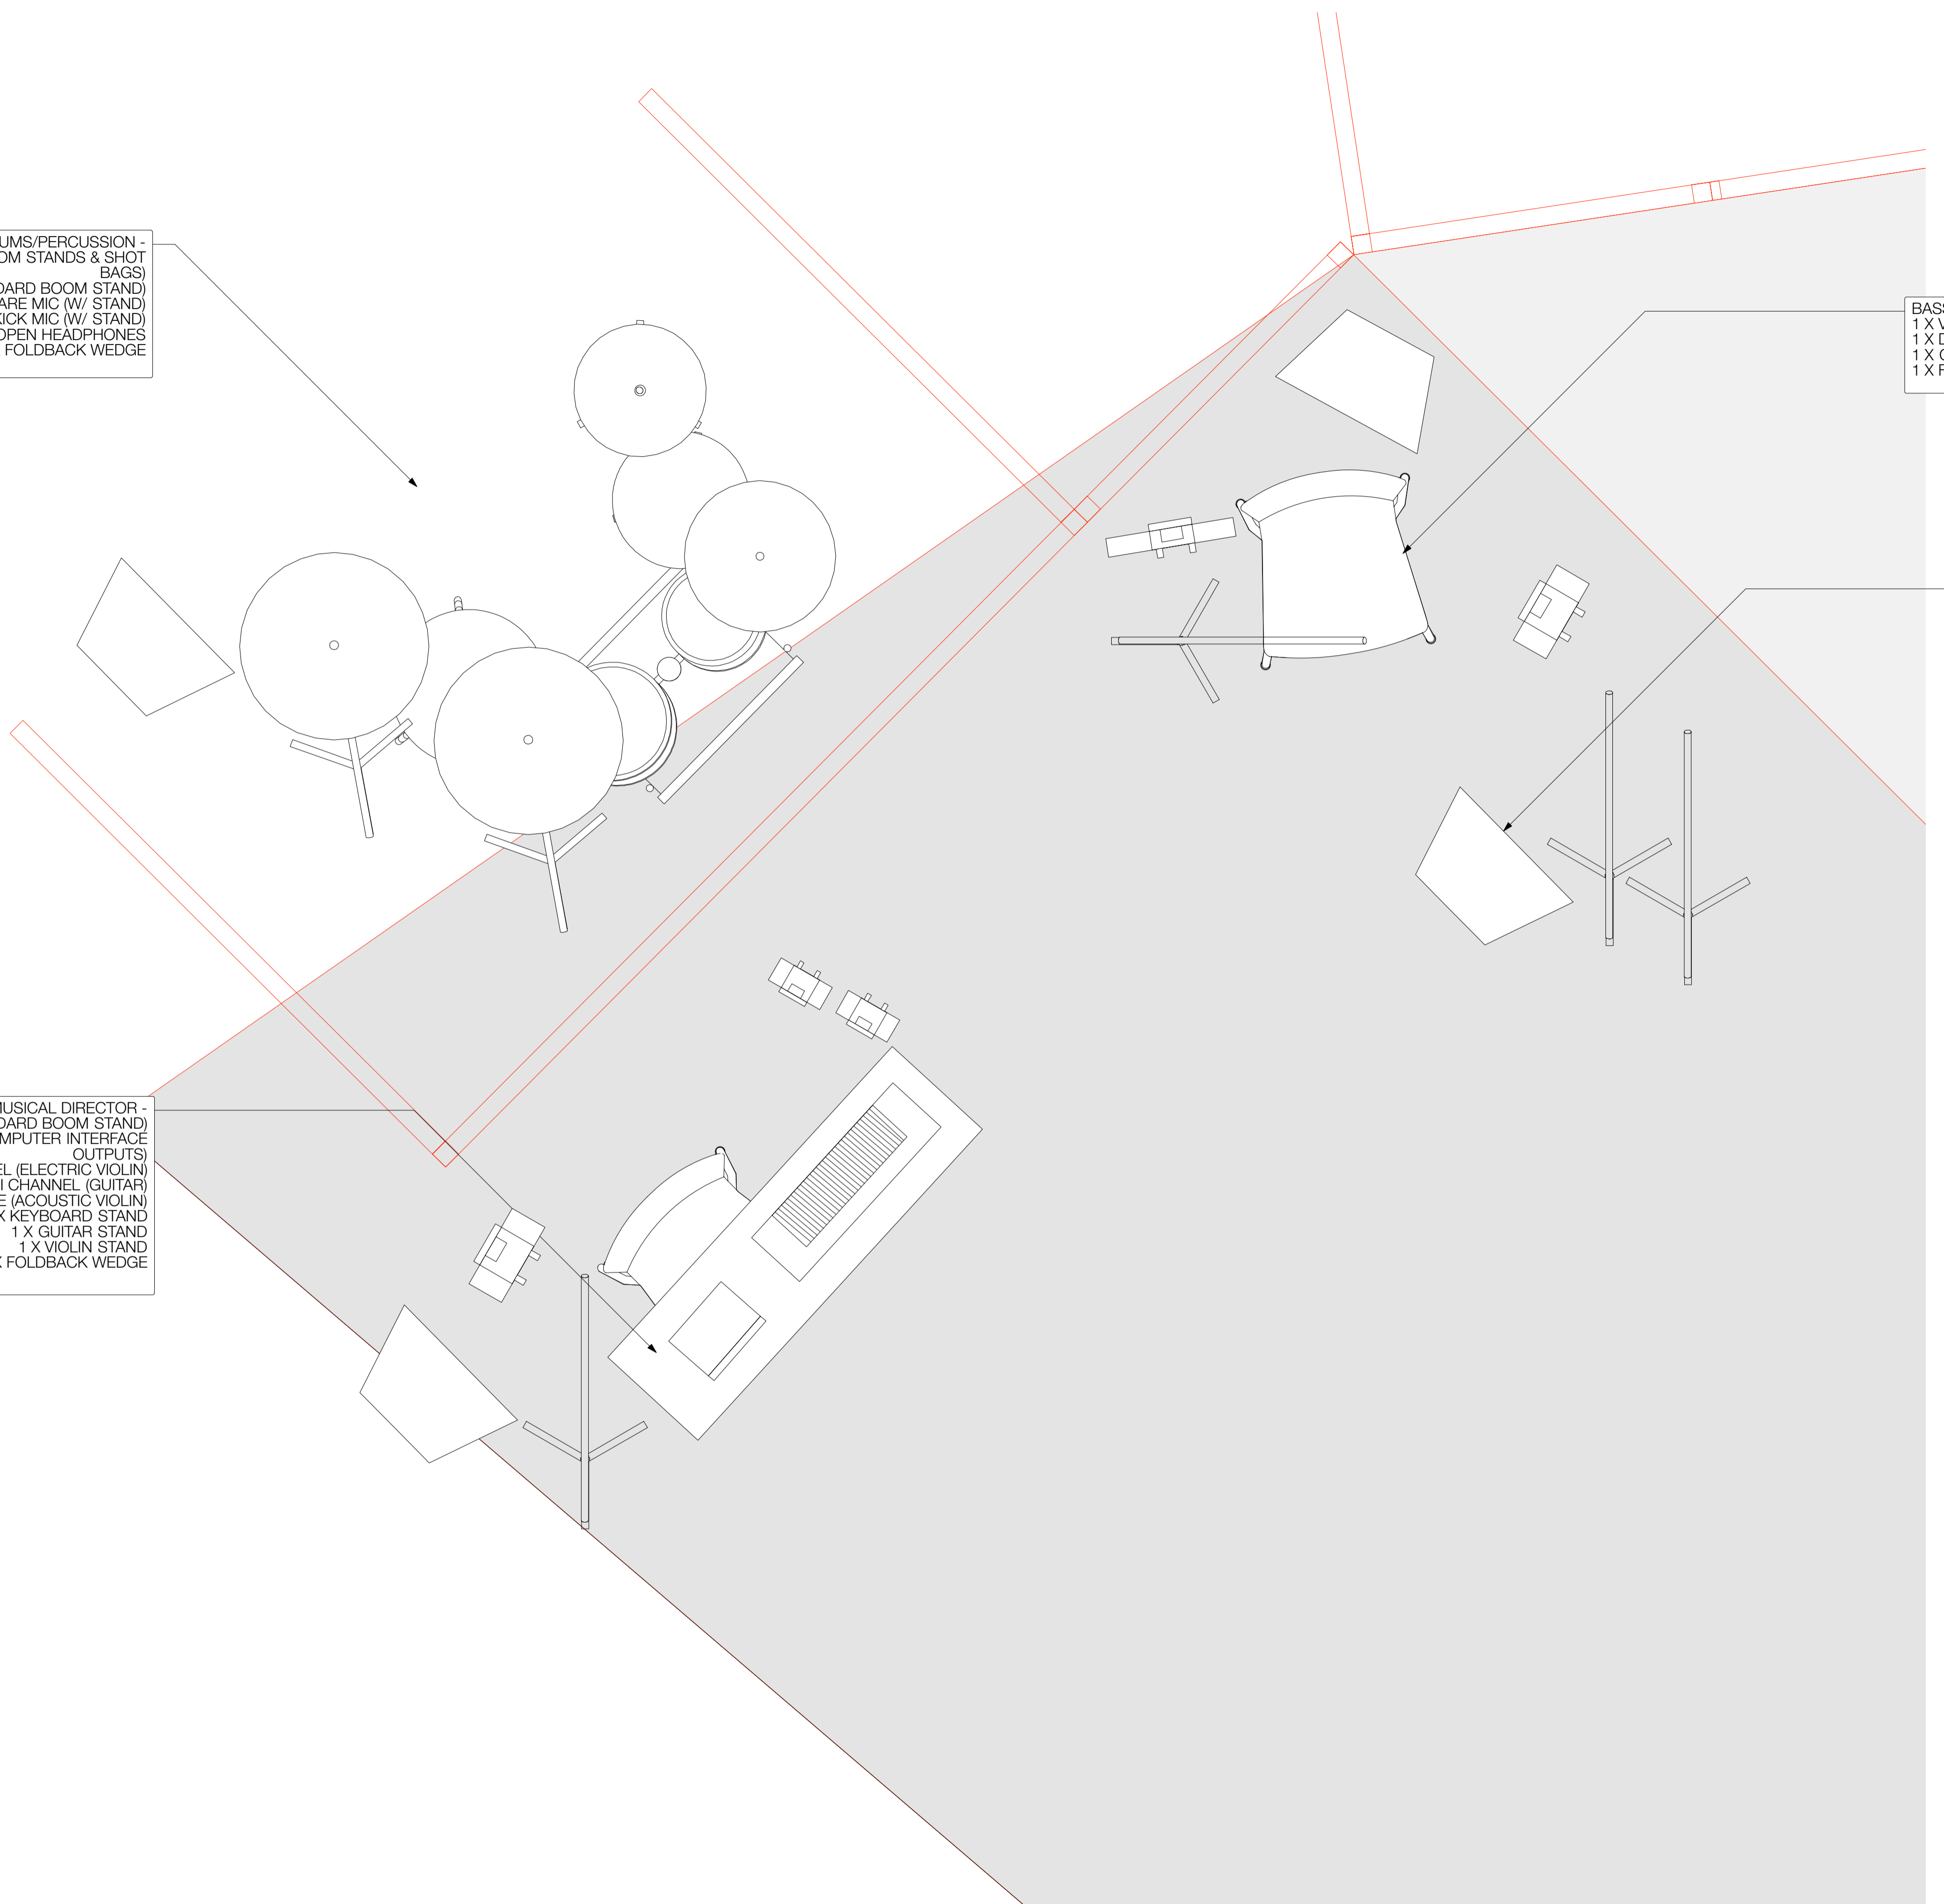

- NOTES**
- FOR GENERAL NOTES REFER TO SHEET SL00-01
  - DO NOT SCALE FROM THESE DRAWINGS
  - ALL DIM TO BE TERMINATED
  - R118 SHOULD BE PROVIDED FOR ALL PROFILES

**REVISIONS**

Preliminary			
NO.	DATE	BY	AMENDMENTS
B	8/10/12	DP	TOUR DRAFT - FOR PARTY APPROVAL
A	15/03/12	MP	INITIAL DRAFT

**BLUEBOTTLE 3 PTY LTD**  
 43 STAWELL STREET NORTH MELBOURNE  
 PHONE 61 3 9329 0709  
 FAX 61 3 9329 1780  
 EMAIL MAIL@BB3.NET.AU  
 © PROFESSIONAL IN CONFIDENCE BLUEBOTTLE 3 PTY LTD

**ELECTRICAL DISCLAIMER**  
 ELECTRICAL CONTRACTOR TO ENSURE COMPLIANCE WITH ALL RELEVANT ELECTRICAL & BUILDING REGULATIONS.  
 BLUEBOTTLE 3 PTY LTD ACCEPTS NO RESPONSIBILITY FOR ENGINEERING, INSTALLATION OR COMPLIANCE OF ELECTRICAL WORKS.

**PROJECT**

NO. NAME  
 J11234 JACK CHARLES VS THE CROWN - GENERIC TOUR

CLIENT  
 ILBIJERRI THEATRE COMPANY


**TITLE**  
**BAND LAYOUT**

DESIGNER DANNY PETTINGILL	VENUE GENERIC
DRAWN BY BB	CHECKED BY NTS
DRAWING NUMBER - REVISION SL04-01 B	SCALE DATE 8/10/12
	ISSUE TOUR DRAFT

**LANTERN SCHEDULE**

DEVICE TYPE	UNIT	POSITION	CHANNEL	INSTRUMENT	LOOM	DIMMER	UNIVERSE	COLOUR	PURPOSE	WATTAGE	Mounting	DMX CHANNELS	FRAME SIZE	GOBO	WEIGHT
Light	4	LX #4		47 ZOOM PROFILE 25-50 DEGREE				L008	BACKLIGHT ARRAY BEHIND SET	800			1 190mm		7.7
Light	6	LX #4		48 ZOOM PROFILE 25-50 DEGREE				L008	BACKLIGHT ARRAY BEHIND SET	800			1 190mm		7.7
Light	8	LX #4		49 ZOOM PROFILE 25-50 DEGREE				L008	BACKLIGHT ARRAY BEHIND SET	800			1 190mm		7.7
Light	9	LX #3		75 PAR 64 MFL				L744	BAND COLOR	300			1		2.8
Light	10	LX #3		76 PAR 64 MFL				L195	BAND COLOR	300			1		2.8
Light	13	LX #3		54 1.2K FRESNEL				L744	WARM BACKLIGHT ARRAY	1200			1 7 3/8"X7 3/8"		5
Light	15	LX #3		55 1.2K FRESNEL				L744	WARM BACKLIGHT ARRAY	1200			1 7 3/8"X7 3/8"		5
Light	18	LX#2		75 PAR 64 MFL				L744	BAND COLOR	300			1		2.8
Light	19	LX#2		76 PAR 64 MFL				L195	BAND COLOR	300			1		2.8
Light	20	LX#2		86 HUNG BC GROUP						180			1		0
Light	22	LX#2		86 HUNG BC GROUP						180			1		0
Light	23	LX#2		49 1.2K FRESNEL				L195	BACKLIGHT FAN	1200			1 7 3/8"X7 3/8"		5
Light	24	LX#2		49 1.2K FRESNEL				L195	BACKLIGHT FAN	1200			1 7 3/8"X7 3/8"		5
Light	25	LX#2		50 1.2K FRESNEL				L195	BACKLIGHT FAN	1200			1 7 3/8"X7 3/8"		5
Light	26	LX#2		50 1.2K FRESNEL				L195	BACKLIGHT FAN	1200			1 7 3/8"X7 3/8"		5
Light	27	LX#2		51 1.2K FRESNEL				L195	BACKLIGHT FAN	1200			1 7 3/8"X7 3/8"		5
Light	28	LX#2		51 1.2K FRESNEL				L195	BACKLIGHT FAN	1200			1 7 3/8"X7 3/8"		5
Light	29	LX#2		81 PINSPOT				O/W	WHEEL TIGHT	150			1		1
Light	30	LX#2		67 1.2K FRESNEL				L102	STAGE TOP SIDE	0			1 7 3/8"X7 3/8"		0
Light	31	LX #1A		71 1.2K FRESNEL				L744	CHAIR BACKLIGHT	0			1 7 3/8"X7 3/8"		0
Light	32	LX#2		43 1.2K FRESNEL				O/W	JACK BEDROOM	1200			1 7 3/8"X7 3/8"		5
Light	33	LX #1A		116 HUNG BC GROUP						180			1		0
Light	34	LX #1		72 ZOOM PROFILE 15-35 DEGREE				L009	BAND TOP	800			1 190mm		7.7
Light	35	LX #1		77 ZOOM PROFILE 25-50 DEGREE				O/W	BEVELLING MACHINE	800			1 190mm		7.7
Light	36	LX #1		30 ZOOM PROFILE 25-50 DEGREE				L162	WARM SIDE	800			1 190mm		7.7
Light	37	LX #1A		88 ZOOM PROFILE 15-35 DEGREE				L202	SET FLASHES	800			1 190mm		7.7
Light	38	LX #1		73 ZOOM PROFILE 15-35 DEGREE				L009	BAND TOP	800			1 190mm		7.7
Light	39	LX #1		74 ZOOM PROFILE 15-35 DEGREE				L009	BAND TOP	800			1 190mm		7.7
Light	40	LX #1A		87 ZOOM PROFILE 15-35 DEGREE				L202	SET FLASHES	800			1 190mm		7.7
Light	41	LX #1		13 1.2K FRESNEL				L103		0			1 7 3/8"X7 3/8"		0
Light	42	LX #1		22 1.2K FRESNEL				L063	COOL TOP	0			1 7 3/8"X7 3/8"		0
Light	45	LX #1		61 ZOOM PROFILE 25-50 DEGREE				O/W	STAGE - FULL	800			1 190mm		7.7
Light	46	LX #1A		80 ZOOM PROFILE 15-35 DEGREE				O/W	WHEEL	800			1 190mm	IRIS	7.7
Light	47	LX #1A		93 1.2K FRESNEL				R119	SET WASH C	1200			1 7 3/8"X7 3/8"		5
Light	48	LX #1		65 ZOOM PROFILE 15-35 DEGREE				O/W	STAGE STEP - LETTERBOX	800			1 190mm		7.7
Light	49	LX #1		26 1.2K FRESNEL				L063	COOL TOP	0			1 7 3/8"X7 3/8"		0
Light	50	LX #1		14 1.2K FRESNEL				L103		0			1 7 3/8"X7 3/8"		0
Light	51	LX #1A		94 1.2K FRESNEL				R119	SET WASH	1200			1 7 3/8"X7 3/8"		5
Light	52	LX #1		70 1.2K FRESNEL				L202	CHAIR DOWNLIGHT	1200			1 7 3/8"X7 3/8"		5
Light	53	LX #1		63 ZOOM PROFILE 25-50 DEGREE				O/W	STAGE - FULL	800			1 190mm		7.7
Light	54	LX #1		27 1.2K FRESNEL				L063	COOL TOP	0			1 7 3/8"X7 3/8"		0
Light	55	LX #1		15 1.2K FRESNEL				L103		0			1 7 3/8"X7 3/8"		0
Light	57	LX #1		89 ZOOM PROFILE 15-35 DEGREE				L202	SET FLASHES	800			1 190mm		7.7
Light	58	LX #1		90 ZOOM PROFILE 15-35 DEGREE				L202	SET FLASHES	800			1 190mm		7.7
Light	59	LX #1		31 ZOOM PROFILE 25-50 DEGREE				L162	WARM SIDE	800			1 190mm		7.7
Light	62	LX #1		78 ZOOM PROFILE 25-50 DEGREE				O/W	BEVELLING MACHINE	800			1 190mm		7.7
Light	64	FOH #1		28 ZOOM PROFILE 25-50 DEGREE				L162	WARM SIDE	800			1 190mm		7.7
Light	65	FOH #1		17 ZOOM PROFILE 15-35 DEGREE				L063	COOL FOH	575			1 190mm		7.7
Light	68	FOH #1		10 1.2K FRESNEL				L103		0			1 7 3/8"X7 3/8"		0
Light	69	FOH #1		8 ZOOM PROFILE 15-35 DEGREE				L103		575			1 190mm		7.7
Light	70	FOH #1		11 1.2K FRESNEL				L103		0			1 7 3/8"X7 3/8"		0
Light	72	FOH #1		79 ZOOM PROFILE 15-35 DEGREE				O/W	JC ADDRESS	575			1 190mm	IRIS	7.7
Light	73	FOH #1		68 ZOOM PROFILE 25-50 DEGREE				O/W	CHAIR AREA	800			1 190mm		7.7
Light	74	FOH #1		9 ZOOM PROFILE 15-35 DEGREE				L103		575			1 190mm		7.7
Light	76	FOH #1		12 1.2K FRESNEL				L103		0			1 7 3/8"X7 3/8"		0
Light	77	FOH #1		18 ZOOM PROFILE 15-35 DEGREE				L063	COOL FOH	575			1 190mm		7.7
Light	80	FOH #1		29 ZOOM PROFILE 25-50 DEGREE				L162	WARM SIDE	800			1 190mm		7.7
Light	82	FOH #2		1 ZOOM PROFILE 15-35 DEGREE				L103	FOH FILL	575			1 190mm		7.7
Light	85	FOH #2		3 ZOOM PROFILE 15-35 DEGREE				L103	FOH FILL	575			1 190mm		7.7
Light	86	FOH #2		20 ZOOM PROFILE 15-35 DEGREE				L063	COOL TOP	575			1 190mm		7.7
Light	87	FOH #2		4 ZOOM PROFILE 15-35 DEGREE				L103	FOH FILL	575			1 190mm		7.7
Light	88	FOH #2		82 ZOOM PROFILE 15-35 DEGREE				O/W	TOMBSTONE	575			1 190mm		7.7
Light	89	FOH #2		21 ZOOM PROFILE 15-35 DEGREE				L063	COOL TOP	575			1 190mm		7.7
Light	90	FOH #2		5 ZOOM PROFILE 15-35 DEGREE				L103	FOH FILL	575			1 190mm		7.7
Light	93	FOH #2		7 ZOOM PROFILE 15-35 DEGREE				L103	FOH FILL	575			1 190mm		7.7
Light	94	FLOOR		96 MR 16 BIRDIE MFL						50			1		0.3
Light	95	FLOOR		97 MR 16 BIRDIE MFL						50			1		0.3
Light	96	FLOOR		98 MR 16 BIRDIE MFL						50			1		0.3
Light	97	FLOOR		99 MR 16 BIRDIE MFL						50			1		0.3
Light	98	FLOOR		85 PINSPOT						150			1		1
Light	99	FLOOR		100 MR 16 BIRDIE MFL						50			1		0.3
Light	100	FLOOR		101 MR 16 BIRDIE MFL						50			1		0.3
Light	101	FLOOR		102 MR 16 BIRDIE MFL						50			1		0.3
Light	102	LX #1A		117 ZOOM PROFILE 15-35 DEGREE				O/W	JACK MUSIC	800			1 190mm		7.7
Light	105	LX #3		300 SELECON PL3						0			1		0
Light	106	LX #1A		400 SELECON PL3						0			1		0

**LEGEND**

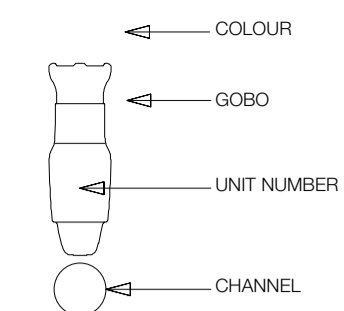

**FIXTURE TYPES**

- NOTES**
- FOR GENERAL NOTES REFER TO SHEET SL00-01
  - DO NOT SCALE FROM THESE DRAWINGS
  - ALL DIM TO BE TERMINATED
  - R119 SHOULD BE PROVIDED FOR ALL PROFILES

**REVISIONS**

Preliminary			
B	8/10/12	DP	TOUR DRAFT - FOR PARTY APPROVAL
A	15/03/12	MP	INITIAL DRAFT
REV	DATE	BY	AMENDMENTS

**BLUEBOTTLE 3 PTY LTD**

43 STAWELL STREET NORTH MELBOURNE  
 PHONE 61 3 9329 0709  
 FAX 61 3 9329 1780  
 EMAIL MAIL@BB3.NET.AU

**ELECTRICAL DISCLAIMER**

ELECTRICAL CONTRACTOR TO ENSURE COMPLIANCE WITH ALL RELEVANT ELECTRICAL & BUILDING REGULATIONS.  
 BLUEBOTTLE 3 PTY LTD ACCEPTS NO RESPONSIBILITY FOR ENGINEERING, INSTALLATION OR COMPLIANCE OF ELECTRICAL WORKS.

**PROJECT**

NO. J11234 NAME JACK CHARLES VS THE CROWN - GENERIC TOUR  
 CLIENT ILBIJERRI THEATRE COMPANY

**TITLE**

**INFORMATION - LANTERN SCHEDULE**


DESIGNER DANNY PETTINGILL	CHECKED BY NTS	VENUE GENERIC	DATE 8/10/12
DRAWN BY BB	SCALE DIP/P	ISSUE	
DRAWING NUMBER - REVISION SL05-01 B			<b>TOUR DRAFT</b>



**PATCH SHEET**

DEVICE TYPE	CHANNEL	LOOM	DIMMER	UNIVERSE	POSITION	UNIT	INSTRUMENT	COLOUR	PURPOSE	WATTAGE	Mounting	DMX CHANNELS	FRAME SIZE	GOBO	WEIGHT
Light	1				FOH #2	82	ZOOM PROFILE 15-35 DEGREE	L103	FOH FILL	575			1 190mm		7.7
Light	3				FOH #2	85	ZOOM PROFILE 15-35 DEGREE	L103	FOH FILL	575			1 190mm		7.7
Light	4				FOH #2	87	ZOOM PROFILE 15-35 DEGREE	L103	FOH FILL	575			1 190mm		7.7
Light	5				FOH #2	90	ZOOM PROFILE 15-35 DEGREE	L103	FOH FILL	575			1 190mm		7.7
Light	7				FOH #2	93	ZOOM PROFILE 15-35 DEGREE	L103	FOH FILL	575			1 190mm		7.7
Light	8				FOH #1	69	ZOOM PROFILE 15-35 DEGREE	L103		575			1 190mm		7.7
Light	9				FOH #1	74	ZOOM PROFILE 15-35 DEGREE	L103		575			1 190mm		7.7
Light	10				FOH #1	68	1.2K FRESNEL	L103		0			1 7 3/8"X7 3/8"		0
Light	11				FOH #1	70	1.2K FRESNEL	L103		0			1 7 3/8"X7 3/8"		0
Light	12				FOH #1	76	1.2K FRESNEL	L103		0			1 7 3/8"X7 3/8"		0
Light	13				LX #1	41	1.2K FRESNEL	L103		0			1 7 3/8"X7 3/8"		0
Light	14				LX #1	50	1.2K FRESNEL	L103		0			1 7 3/8"X7 3/8"		0
Light	15				LX #1	55	1.2K FRESNEL	L103		0			1 7 3/8"X7 3/8"		0
Light	17				FOH #1	65	ZOOM PROFILE 15-35 DEGREE	L063	COOL FOH	575			1 190mm		7.7
Light	18				FOH #1	77	ZOOM PROFILE 15-35 DEGREE	L063	COOL FOH	575			1 190mm		7.7
Light	20				FOH #2	86	ZOOM PROFILE 15-35 DEGREE	L063	COOL TOP	575			1 190mm		7.7
Light	21				FOH #2	89	ZOOM PROFILE 15-35 DEGREE	L063	COOL TOP	575			1 190mm		7.7
Light	22				LX #1	42	1.2K FRESNEL	L063	COOL TOP	0			1 7 3/8"X7 3/8"		0
Light	26				LX #1	49	1.2K FRESNEL	L063	COOL TOP	0			1 7 3/8"X7 3/8"		0
Light	27				LX #1	54	1.2K FRESNEL	L063	COOL TOP	0			1 7 3/8"X7 3/8"		0
Light	28				FOH #1	64	ZOOM PROFILE 25-50 DEGREE	L162	WARM SIDE	800			1 190mm		7.7
Light	29				FOH #1	80	ZOOM PROFILE 25-50 DEGREE	L162	WARM SIDE	800			1 190mm		7.7
Light	30				LX #1	36	ZOOM PROFILE 25-50 DEGREE	L162	WARM SIDE	800			1 190mm		7.7
Light	31				LX #1	59	ZOOM PROFILE 25-50 DEGREE	L162	WARM SIDE	800			1 190mm		7.7
Light	43				LX#2	32	1.2K FRESNEL	O/W	JACK BEDROOM	1200			1 7 3/8"X7 3/8"		5
Light	47				LX #4	4	ZOOM PROFILE 25-50 DEGREE	L008	BACKLIGHT ARRAY BEHIND SET	800			1 190mm		7.7
Light	48				LX #4	6	ZOOM PROFILE 25-50 DEGREE	L008	BACKLIGHT ARRAY BEHIND SET	800			1 190mm		7.7
Light	49				LX#2	23	1.2K FRESNEL	L195	BACKLIGHT FAN	1200			1 7 3/8"X7 3/8"		5
Light	49				LX #4	8	ZOOM PROFILE 25-50 DEGREE	L008	BACKLIGHT ARRAY BEHIND SET	800			1 190mm		7.7
Light	49				LX#2	24	1.2K FRESNEL	L195	BACKLIGHT FAN	1200			1 7 3/8"X7 3/8"		5
Light	50				LX#2	25	1.2K FRESNEL	L195	BACKLIGHT FAN	1200			1 7 3/8"X7 3/8"		5
Light	50				LX#2	26	1.2K FRESNEL	L195	BACKLIGHT FAN	1200			1 7 3/8"X7 3/8"		5
Light	51				LX#2	28	1.2K FRESNEL	L195	BACKLIGHT FAN	1200			1 7 3/8"X7 3/8"		5
Light	51				LX#2	27	1.2K FRESNEL	L195	BACKLIGHT FAN	1200			1 7 3/8"X7 3/8"		5
Light	54				LX #3	13	1.2K FRESNEL	L744	WARM BACKLIGHT ARRAY	1200			1 7 3/8"X7 3/8"		5
Light	55				LX #3	15	1.2K FRESNEL	L744	WARM BACKLIGHT ARRAY	1200			1 7 3/8"X7 3/8"		5
Light	61				LX #1	45	ZOOM PROFILE 25-50 DEGREE	O/W	STAGE - FULL	800			1 190mm		7.7
Light	63				LX #1	53	ZOOM PROFILE 25-50 DEGREE	O/W	STAGE - FULL	800			1 190mm		7.7
Light	65				LX #1	48	ZOOM PROFILE 15-35 DEGREE	O/W	STAGE STEP - LETTERBOX	800			1 190mm		7.7
Light	67				LX#2	30	1.2K FRESNEL	L102	STAGE TOP SIDE	0			1 7 3/8"X7 3/8"		0
Light	68				FOH #1	73	ZOOM PROFILE 25-50 DEGREE	O/W	CHAIR AREA	800			1 190mm		7.7
Light	70				LX #1	52	1.2K FRESNEL	L202	CHAIR DOWNLIGHT	1200			1 7 3/8"X7 3/8"		5
Light	71				LX #1A	31	1.2K FRESNEL	L744	CHAIR BACKLIGHT	0			1 7 3/8"X7 3/8"		0
Light	72				LX #1	34	ZOOM PROFILE 15-35 DEGREE	L009	BAND TOP	800			1 190mm		7.7
Light	73				LX #1	38	ZOOM PROFILE 15-35 DEGREE	L009	BAND TOP	800			1 190mm		7.7
Light	74				LX #1	39	ZOOM PROFILE 15-35 DEGREE	L009	BAND TOP	800			1 190mm		7.7
Light	75				LX#2	18	PAR 64 MFL	L744	BAND COLOR	300			1		2.8
Light	75				LX #3	9	PAR 64 MFL	L744	BAND COLOR	300			1		2.8
Light	76				LX #3	10	PAR 64 MFL	L195	BAND COLOR	300			1		2.8
Light	76				LX#2	19	PAR 64 MFL	L195	BAND COLOR	300			1		2.8
Light	77				LX #1	35	ZOOM PROFILE 25-50 DEGREE	O/W	BEVELLING MACHINE	800			1 190mm		7.7
Light	78				LX #1	62	ZOOM PROFILE 25-50 DEGREE	O/W	BEVELLING MACHINE	800			1 190mm		7.7
Light	79				FOH #1	72	ZOOM PROFILE 15-35 DEGREE	O/W	JC ADDRESS	575			1 190mm	IRIS	7.7
Light	80				LX #1A	46	ZOOM PROFILE 15-35 DEGREE	O/W	WHEEL	800			1 190mm	IRIS	7.7
Light	81				LX#2	29	PINSPOT	O/W	WHEEL TIGHT	150			1		1
Light	82				FOH #2	88	ZOOM PROFILE 15-35 DEGREE	O/W	TOMBSTONE	575			1 190mm		7.7
Light	85				FLOOR	98	PINSPOT			150			1		1
Light	86				LX#2	22	HUNG BC GROUP			180			1		0
Light	86				LX#2	20	HUNG BC GROUP			180			1		0
Light	87				LX #1A	40	ZOOM PROFILE 15-35 DEGREE	L202	SET FLASHES	800			1 190mm		7.7
Light	88				LX #1A	37	ZOOM PROFILE 15-35 DEGREE	L202	SET FLASHES	800			1 190mm		7.7
Light	89				LX #1	57	ZOOM PROFILE 15-35 DEGREE	L202	SET FLASHES	800			1 190mm		7.7
Light	90				LX #1	58	ZOOM PROFILE 15-35 DEGREE	L202	SET FLASHES	800			1 190mm		7.7
Light	93				LX #1A	47	1.2K FRESNEL	R119	SET WASH C	1200			1 7 3/8"X7 3/8"		5
Light	94				LX #1A	51	1.2K FRESNEL	R119	SET WASH	1200			1 7 3/8"X7 3/8"		5
Light	96				FLOOR	94	MR 16 BIRDIE MFL			50			1		0.3
Light	97				FLOOR	95	MR 16 BIRDIE MFL			50			1		0.3
Light	98				FLOOR	96	MR 16 BIRDIE MFL			50			1		0.3
Light	99				FLOOR	97	MR 16 BIRDIE MFL			50			1		0.3
Light	100				FLOOR	99	MR 16 BIRDIE MFL			50			1		0.3
Light	101				FLOOR	100	MR 16 BIRDIE MFL			50			1		0.3
Light	102				FLOOR	101	MR 16 BIRDIE MFL			50			1		0.3
Light	116				LX #1A	33	HUNG BC GROUP			180			1		0
Light	117				LX #1A	102	ZOOM PROFILE 15-35 DEGREE	O/W	JACK MUSIC	800			1 190mm		7.7
Light	300				LX #3	105	SELECON PL3			0			1		0
Light	400				LX #1A	106	SELECON PL3			0			1		0

**LEGEND**

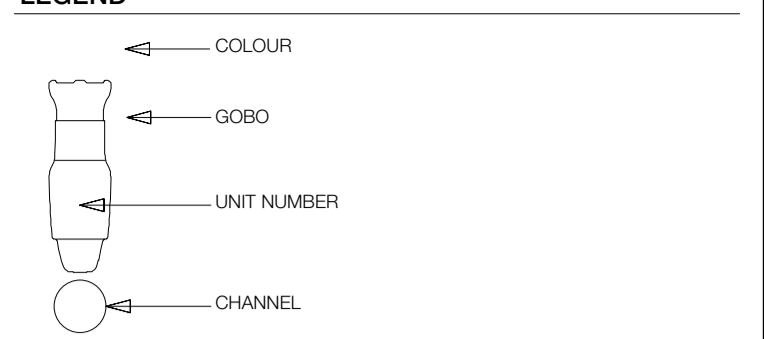

**FIXTURE TYPES**

- NOTES**  
 1. FOR GENERAL NOTES REFER TO SHEET SL00-01  
 2. DO NOT SCALE FROM THESE DRAWINGS  
 3. ALL DIM TO BE TERMINATED  
 4. R119 SHOULD BE PROVIDED FOR ALL PROFILES

**REVISIONS**

Preliminary			
REV	DATE	BY	AMENDMENTS
B	8/10/12	DP	TOUR DRAFT - FOR PARY APPROVAL
A	15/03/12	MP	INITIAL DRAFT

**BLUEBOTTLE 3 PTY LTD**  
 43 STAWELL STREET NORTH MELBOURNE  
 PHONE 61 3 9329 0709  
 FAX 61 3 9329 1780  
 EMAIL MAIL@BB3.NET.AU

**ELECTRICAL DISCLAIMER**  
 ELECTRICAL CONTRACTOR TO ENSURE COMPLIANCE WITH ALL RELEVANT ELECTRICAL & BUILDING REGULATIONS.  
 BLUEBOTTLE 3 PTY LTD ACCEPTS NO RESPONSIBILITY FOR ENGINEERING, INSTALLATION OR COMPLIANCE OF ELECTRICAL WORKS.

**PROJECT**  
 NO. J11234 NAME JACK CHARLES VS THE CROWN - GENERIC TOUR  
 CLIENT ILBIJERRI THEATRE COMPANY

**TITLE**  
 PATCH - CHANNEL SCHEDULE

DESIGNER DANNY PETTINGILL	CHECKED BY NTS	VENUE GENERIC	SCALE NTS	DATE 8/10/12
DRAWN BY BB	DRAWING NUMBER - REVISION SL05-02	ISSUE TOUR DRAFT		

1/12/2012 10:58:03 AM

